


INDEX TO DRAWINGS

- A-1. SITE PLAN
- A-2 "C" COMPLEX SITE PLAN
- A-3 "D" COMPLEX SITE PLAN
- A-4 "E" COMPLEX SITE PLAN
- A-5 FOUNDATION PLAN, SCREEN WALL & KITCHEN CABINETS
- A-6 FLOOR PLAN, DOOR SCHEDULE & DETAILS
- A-7 BUILDING ELEVATIONS
- A-8 ROOF FRAMING PLAN & DETAILS
- A-9 WALL SECTIONS
- A-10 WALL SECTIONS
- M-II MECHANICAL
- E-12 ELECTRICAL
- R-13 REMODELING OF INDIVIDUAL HOUSING UNITS
- R-14 REMODELING OF CENTRAL UTILITY BUILDING (WASHATERIA)
- R-15 REMODELING OF CENTRAL UTILITY BUILDING (WASHATERIA)


DRAWING SYMBOLS

- LETTER INDICATES DETAIL SHEET NUMBER
- LETTER INDICATES CROSS SECTION SHEET NUMBER
- LETTER INDICATES DOOR TYPE DOOR NUMBER
- LETTER INDICATES WINDOW TYPE
- INDICATES LOCATION OF ELECTRICAL SERVICE
- NUMBER INDICATES FINISH FLOOR ELEVATION

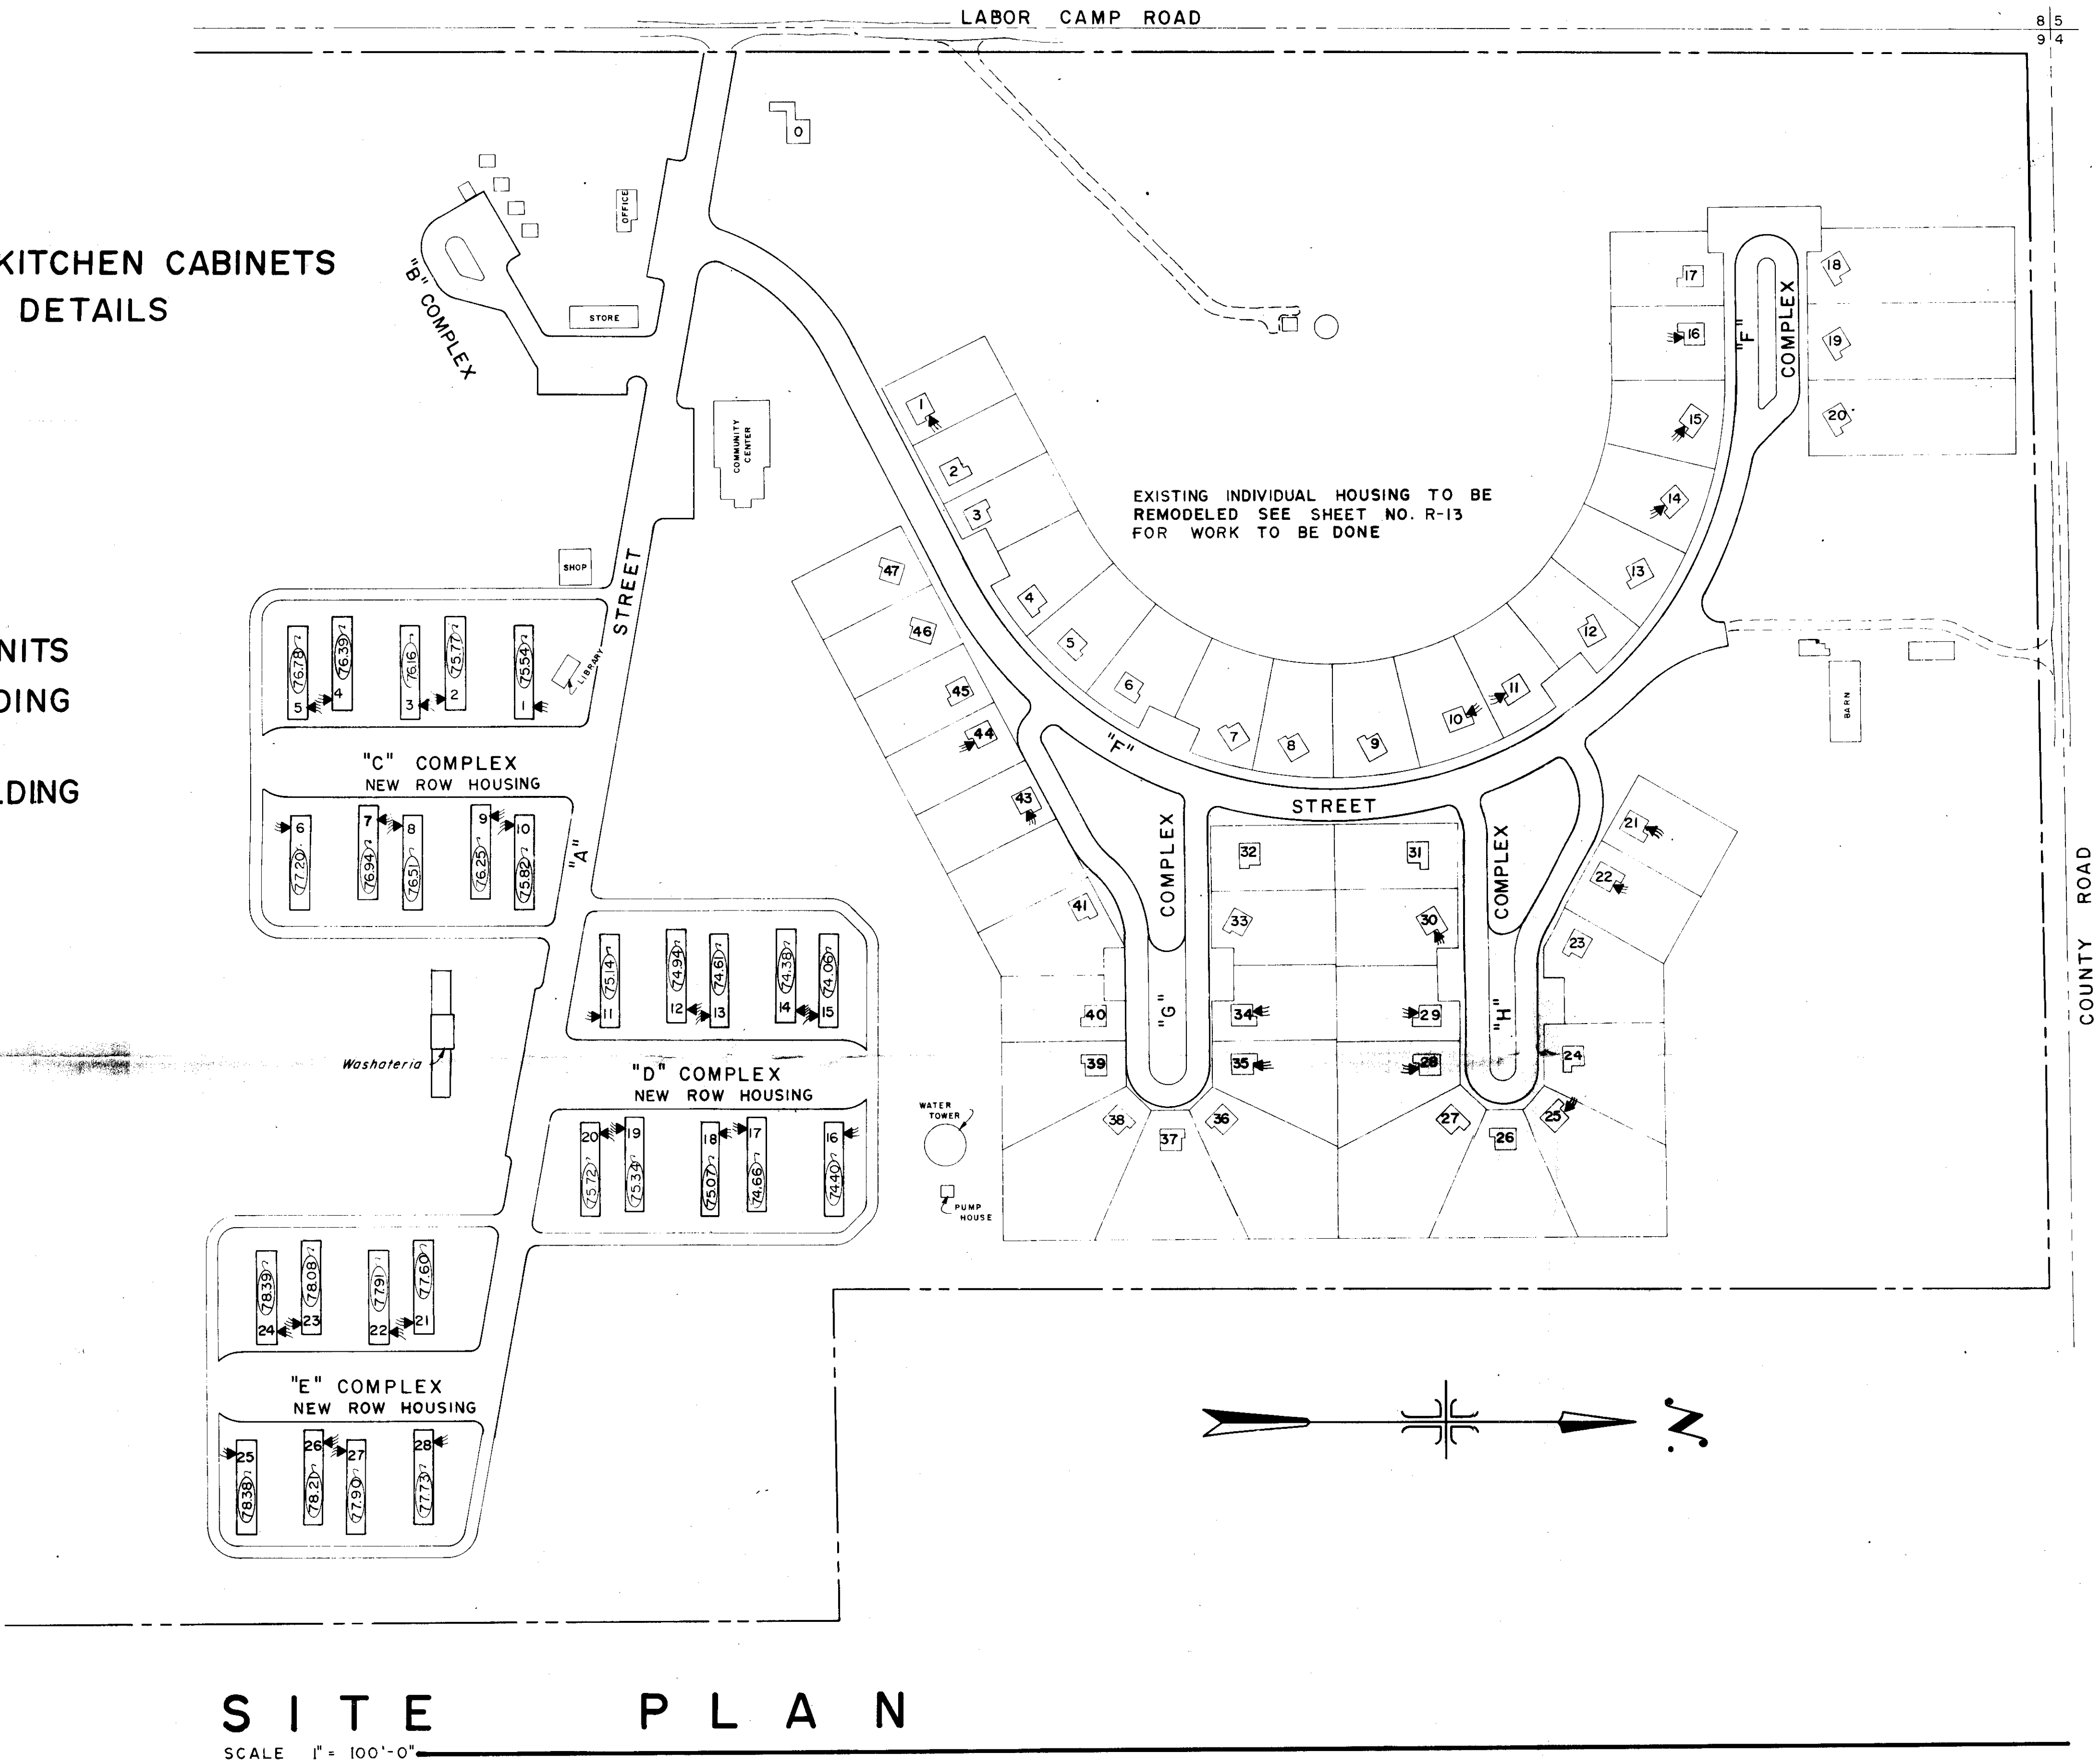


THOMPSON & KOLBO Architects
A.I.A.
7071 FAIRVIEW AVENUE
717 ROOSEVELT AVENUE
BOISE, IDAHO
Nampa, IDAHO


for
FARM LABOR CAMP
Caldwell Housing Authority
CANYON COUNTY, IDAHO

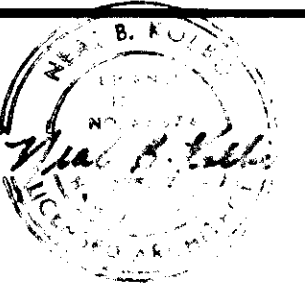

T	
K	
DRAWN BY:	DATE:
RS	9-8-69
CHECKED:	JOB NO.:
	6916
SHEET NUMBER	
A-1	
1 OF 15	

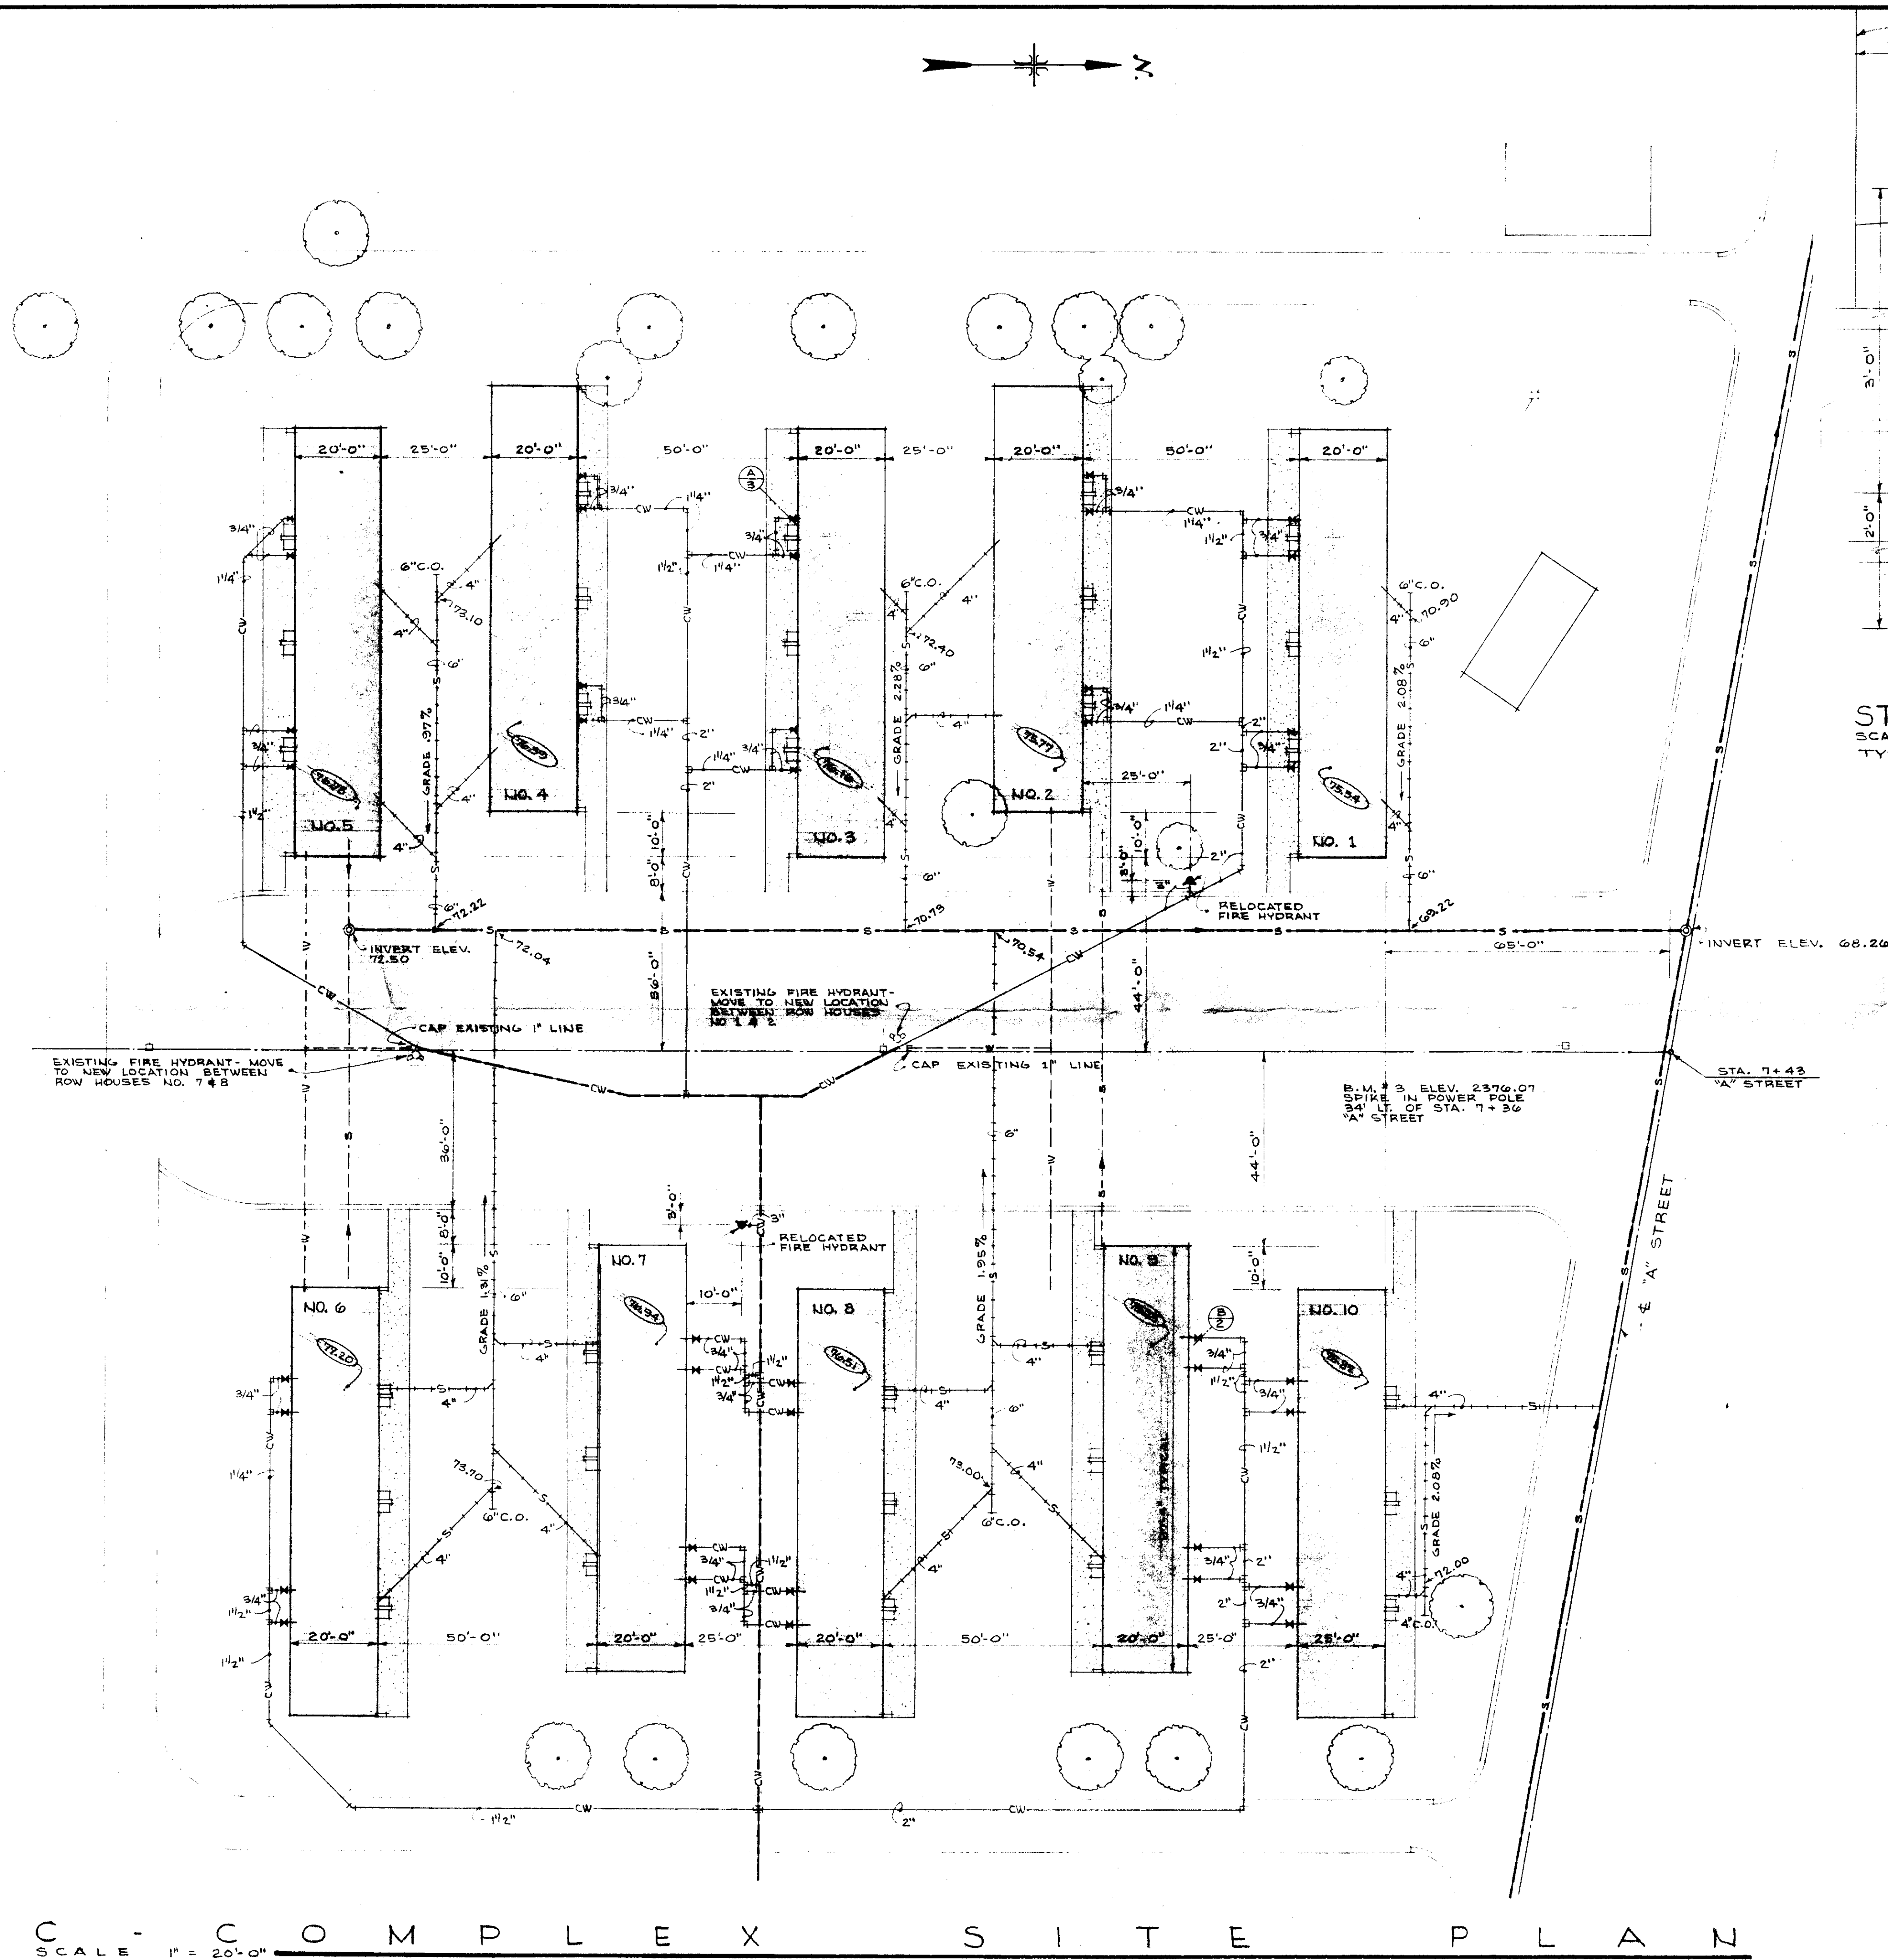

C O M P L E X S I T E P L A N
SCALE 1" = 20'-0"

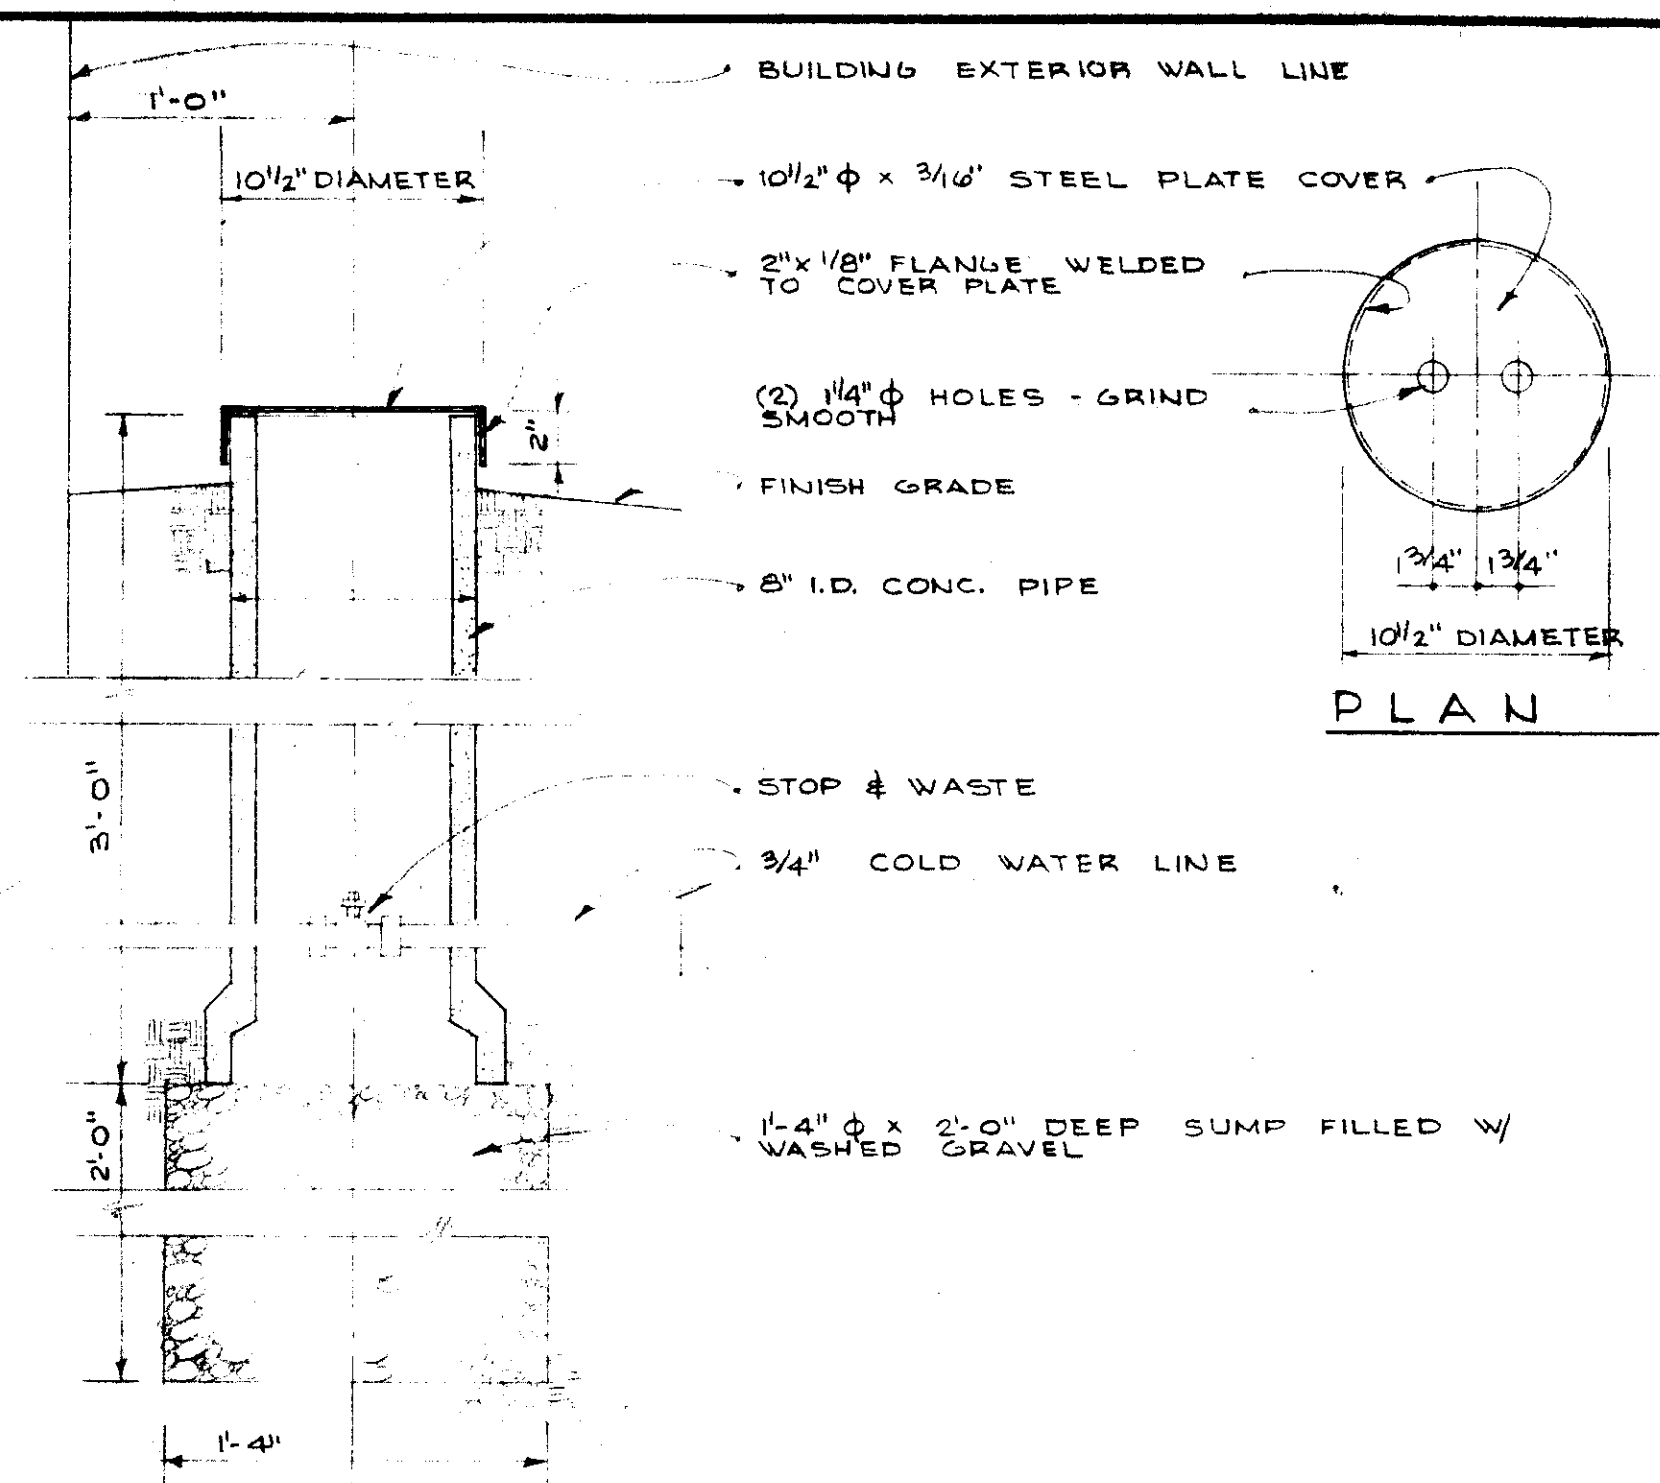

STOP & WASTE DETAIL (B)
SCALE 1/2" = 1'-0"
TYPICAL WHERE WASTE ENTERS FROM REAR OF HOUSING UNIT

DRAWING SYMBOLS	
— S — S —	EXISTING SEWER LINE TO REMAIN IN SERVICE
- - S - - S - -	EXISTING SEWER LINE TO BE ABANDON
— S — S —	EXISTING MAN HOLE TO REMAIN IN SERVICE
— S — S —	NEW SEWER LINE BY PLUMBING CONTRACTOR - SIZE AS SHOWN
- - CW - - CW - -	EXISTING COLD WATER SUPPLY LINE TO REMAIN IN SERVICE
- - W - - W - -	EXISTING WATER LINE TO BE ABANDON - CAP AS SHOWN
- - CW - - CW - -	NEW COLD WATER LINE BY PLUMBING CONTRACTOR SIZE AS SHOWN
— CW — CW —	STOP & WASTE IN NEW COLD WATER LINE BY PLUMBING CONTRACTOR SEE DETAIL 1/2" x 1/4"
72.50	INDICATES ELEVATION OF NEW SEWER LINES IN FEET & HUNDREDTHS
72.50	INDICATES ELEVATION OF BUILDING FINISH FLOOR LINE IN FEET & HUNDREDTHS

THOMPSON & KOLBO Architects
A.I.A.
 7071 FAIRVIEW AVENUE
 717 ROOSEVELT AVENUE
 BOISE, IDAHO
 Nampa, IDAHO

for
FARM LABOR CAMP CALDWELL HOUSING AUTHORITY
 CANYON COUNTY, IDAHO

A-2
 2 OF 2



B.M. 44 ELEV. 2376.91
 5' IN CONC. STRUCTURE
 27' RT. OF STA. 10+43
 "A" STREET

STA. 10+03.04
 "A" STREET

NOTE: SEE SHEET NO. 2 FOR SYMBOLS

D - C O M P L E X S I T E P L A N

SCALE 1" = 20'-0"

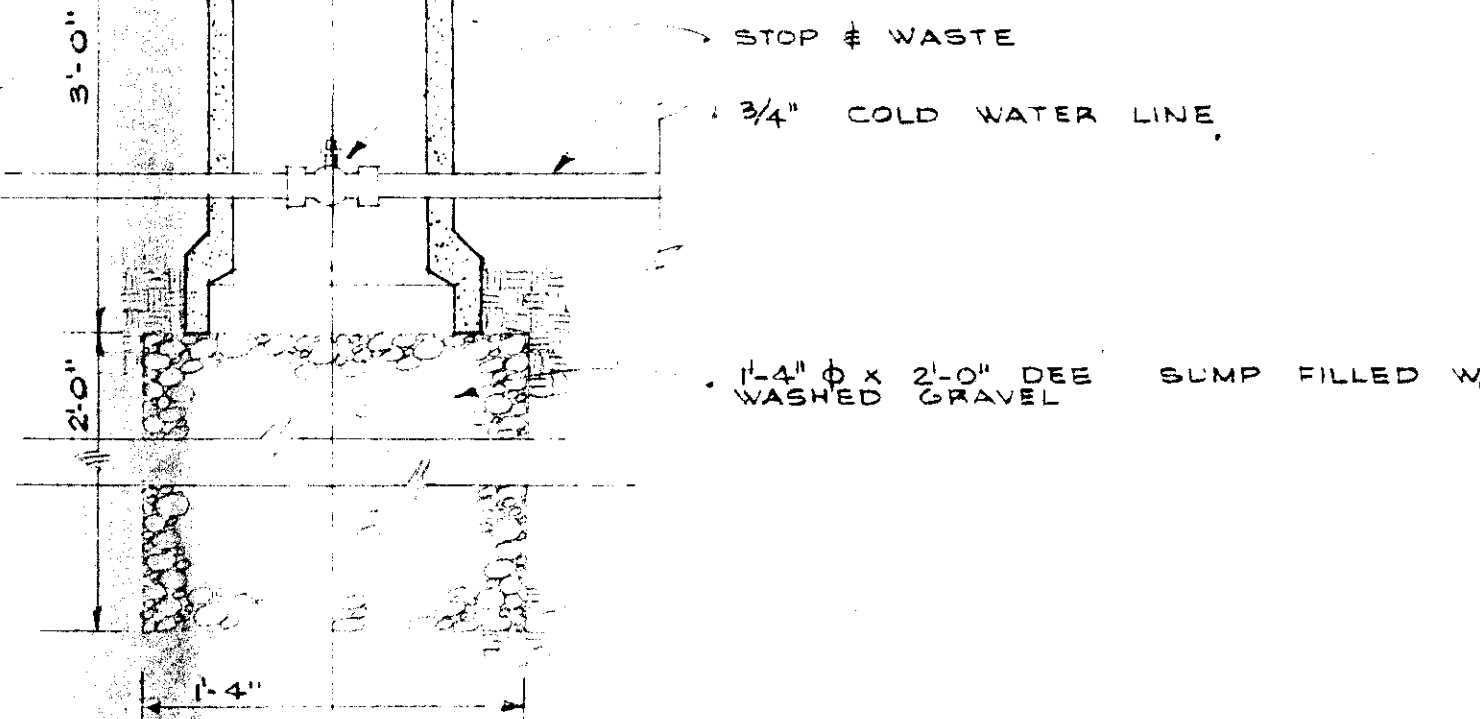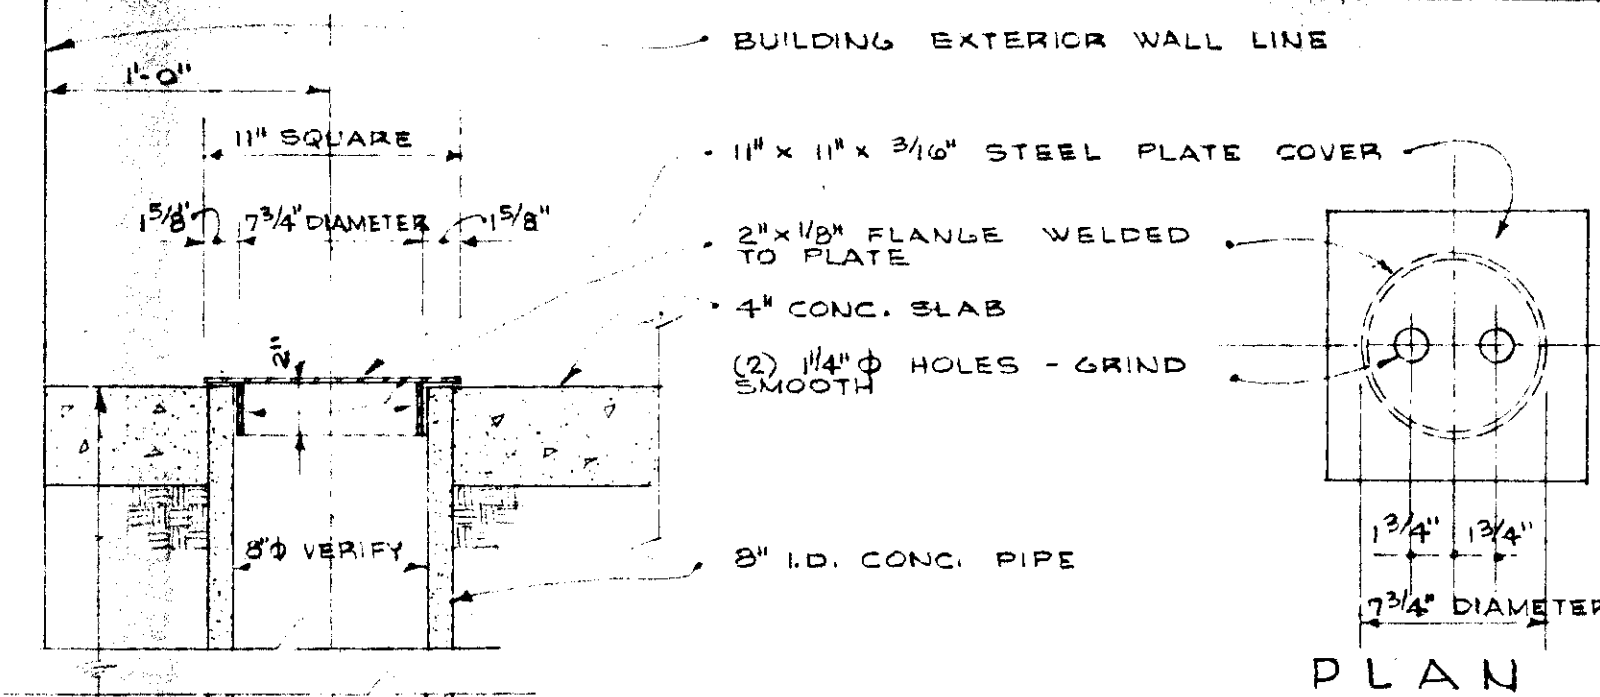


STOP & WASTE DETAIL (A)
 SCALE 1 1/2" = 1'-0"
 TYPICAL WHERE WASTE ENTERS FROM FRONT OF HOUSING UNIT

for
 FARM LABOR CAMP
 CALDWELL HOUSING AUTHORITY
 CANYON COUNTY, IDAHO



	DRAWN BY: RS CHECKED: 6916 SHEET NUMBER: A-3 3 OF 15	DATE: 9-8-69 JOB NO.: 6916
--	---	-------------------------------

THOMPSON & KOLBO Architects
 A.I.A.
 7071 FAIRVIEW AVENUE
 717 ROOSEVELT AVENUE
 BOISE, IDAHO
 Nampa, Idaho

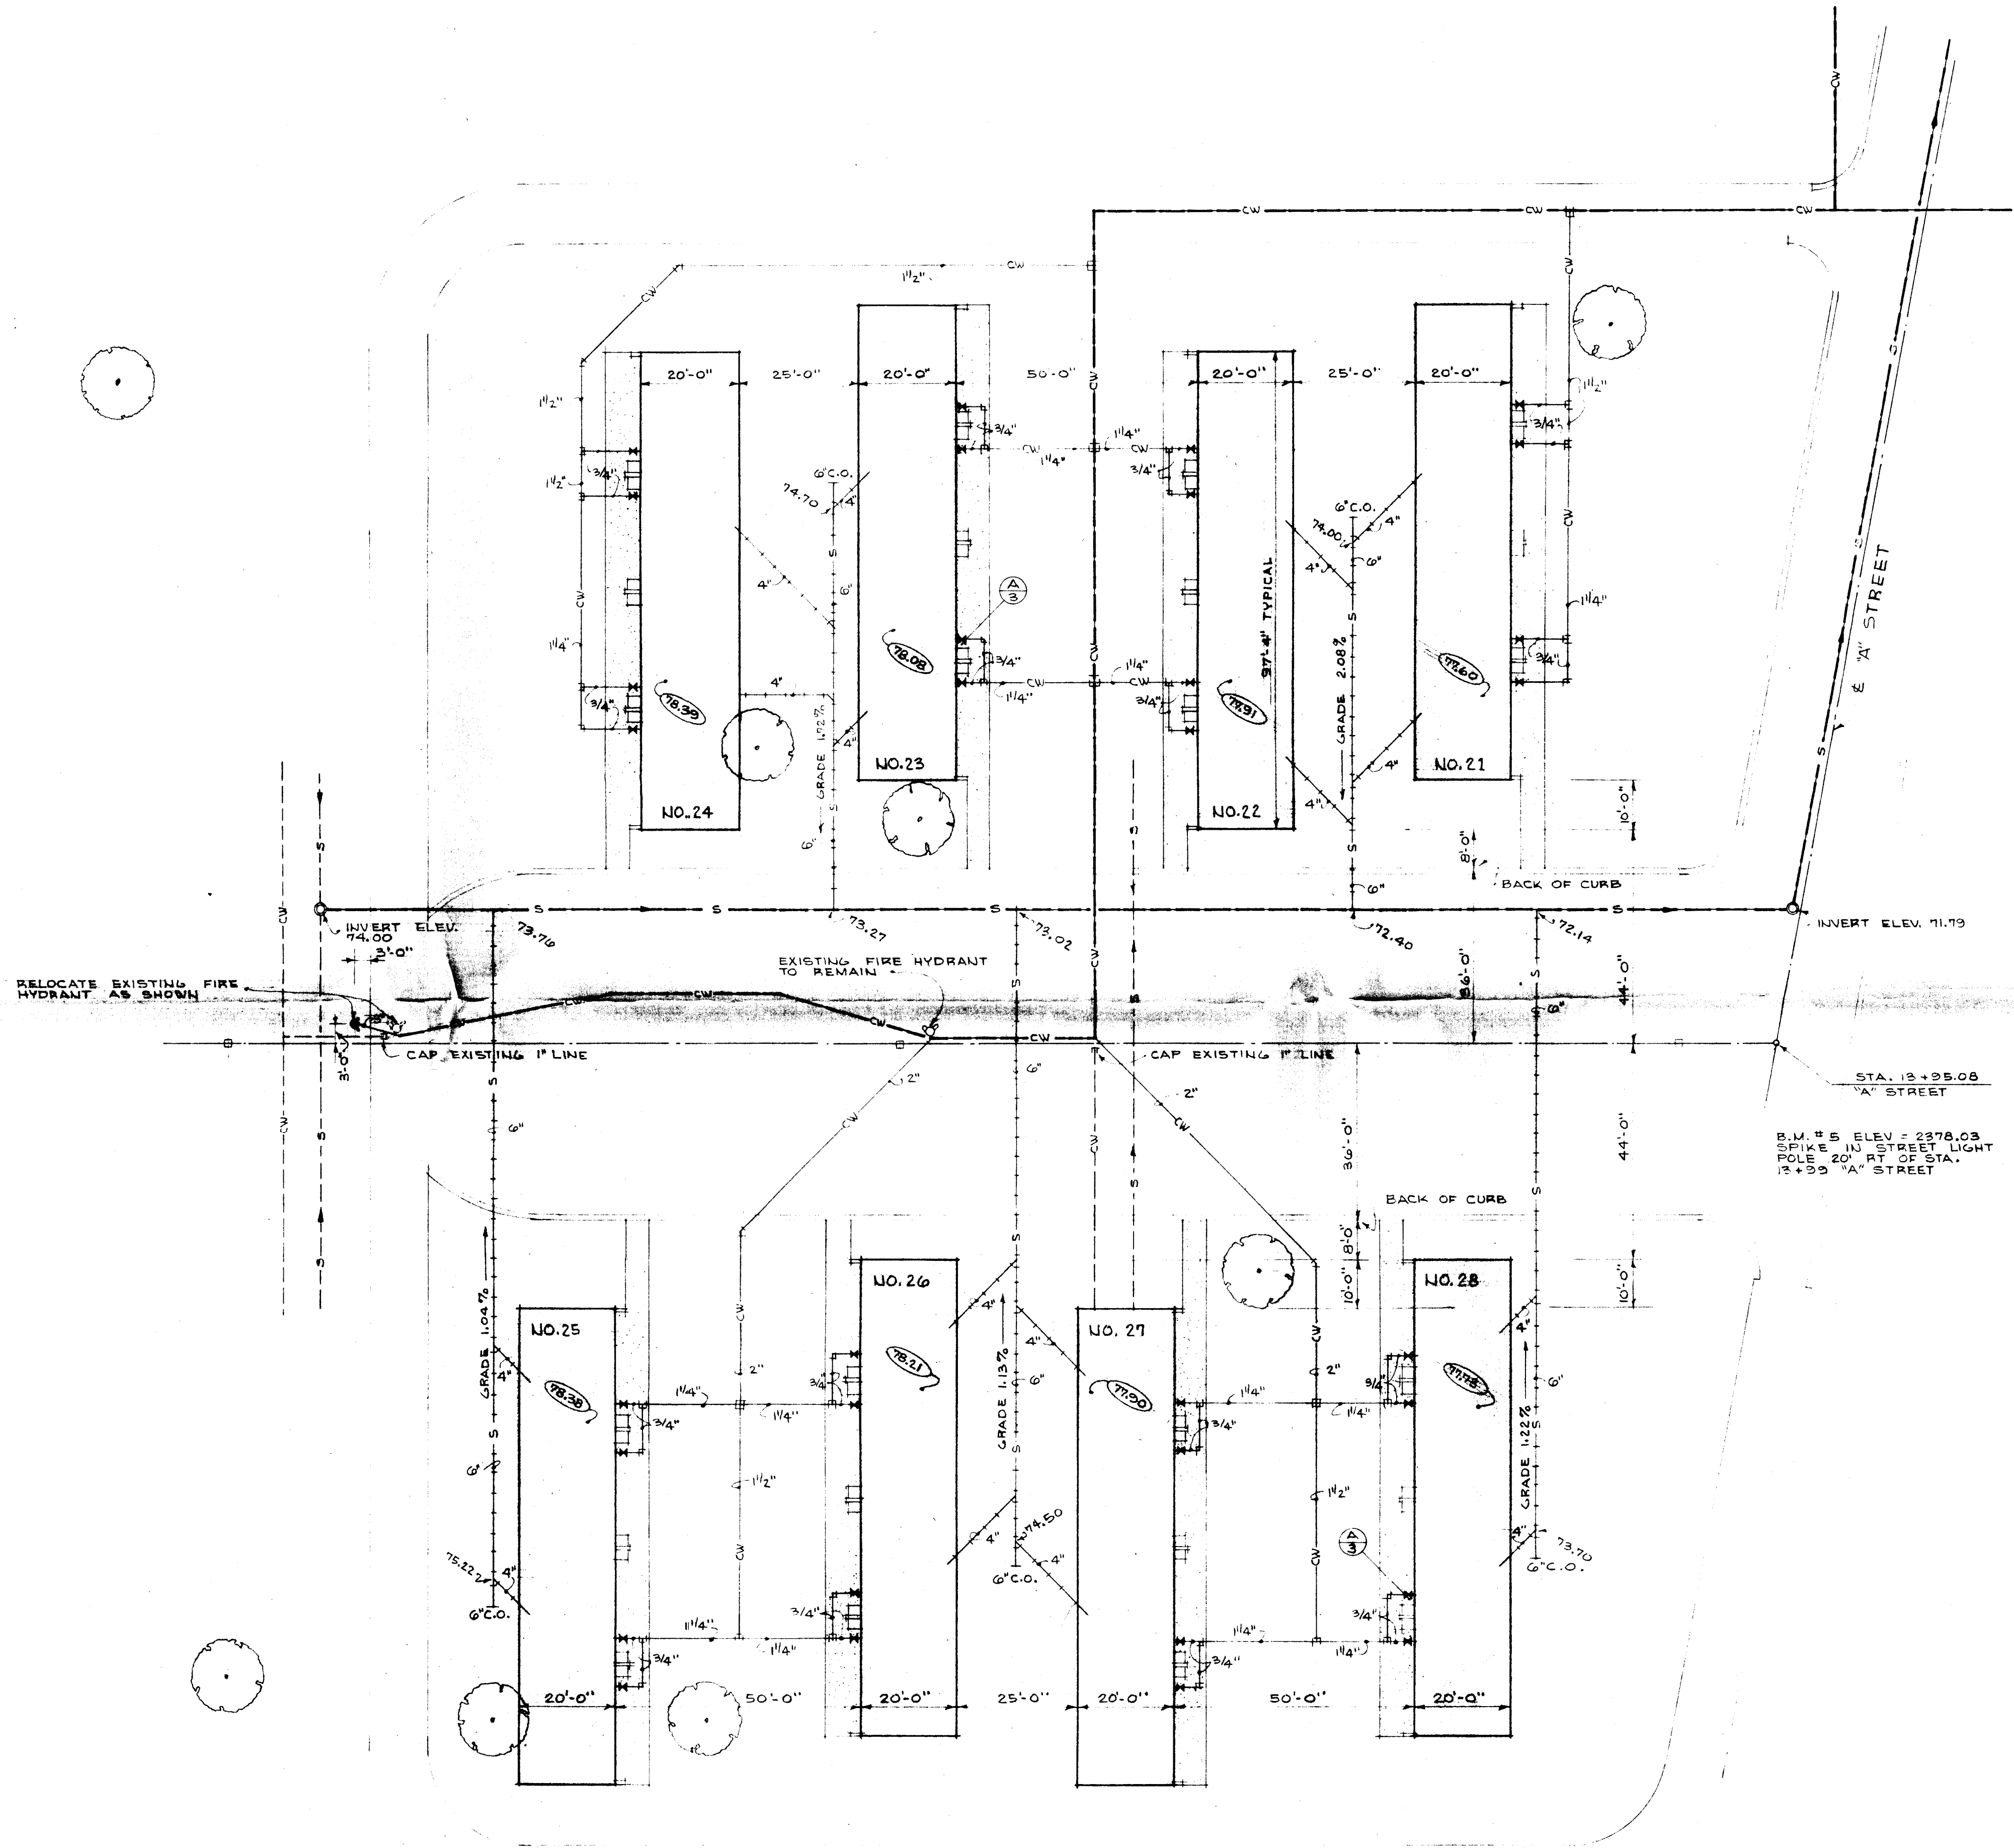


NOTE: SEE SHEET NO. 2 FOR SYMBOLS

E - C O M P L E X S I T E P L A N





SCALE = 1" = 20'-0"


THOMPSON & KOLBO Architects
A.I.A.
7071 FAIRVIEW AVENUE
717 ROOSEVELT AVENUE
BOISE, IDAHO
Nampa, IDAHO

for
FARM LABOR CAMP
CALDWELL HOUSING AUTHORITY
IDAHO
CANYON COUNTY,

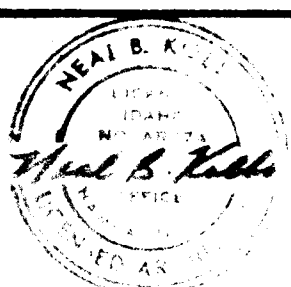

T	
K	
DRAWN BY: RCS	DATE: 9-8-69
CHECKED BY: A	JOB NO.: 6916
SHEET NUMBER A-4 4 OF 15	

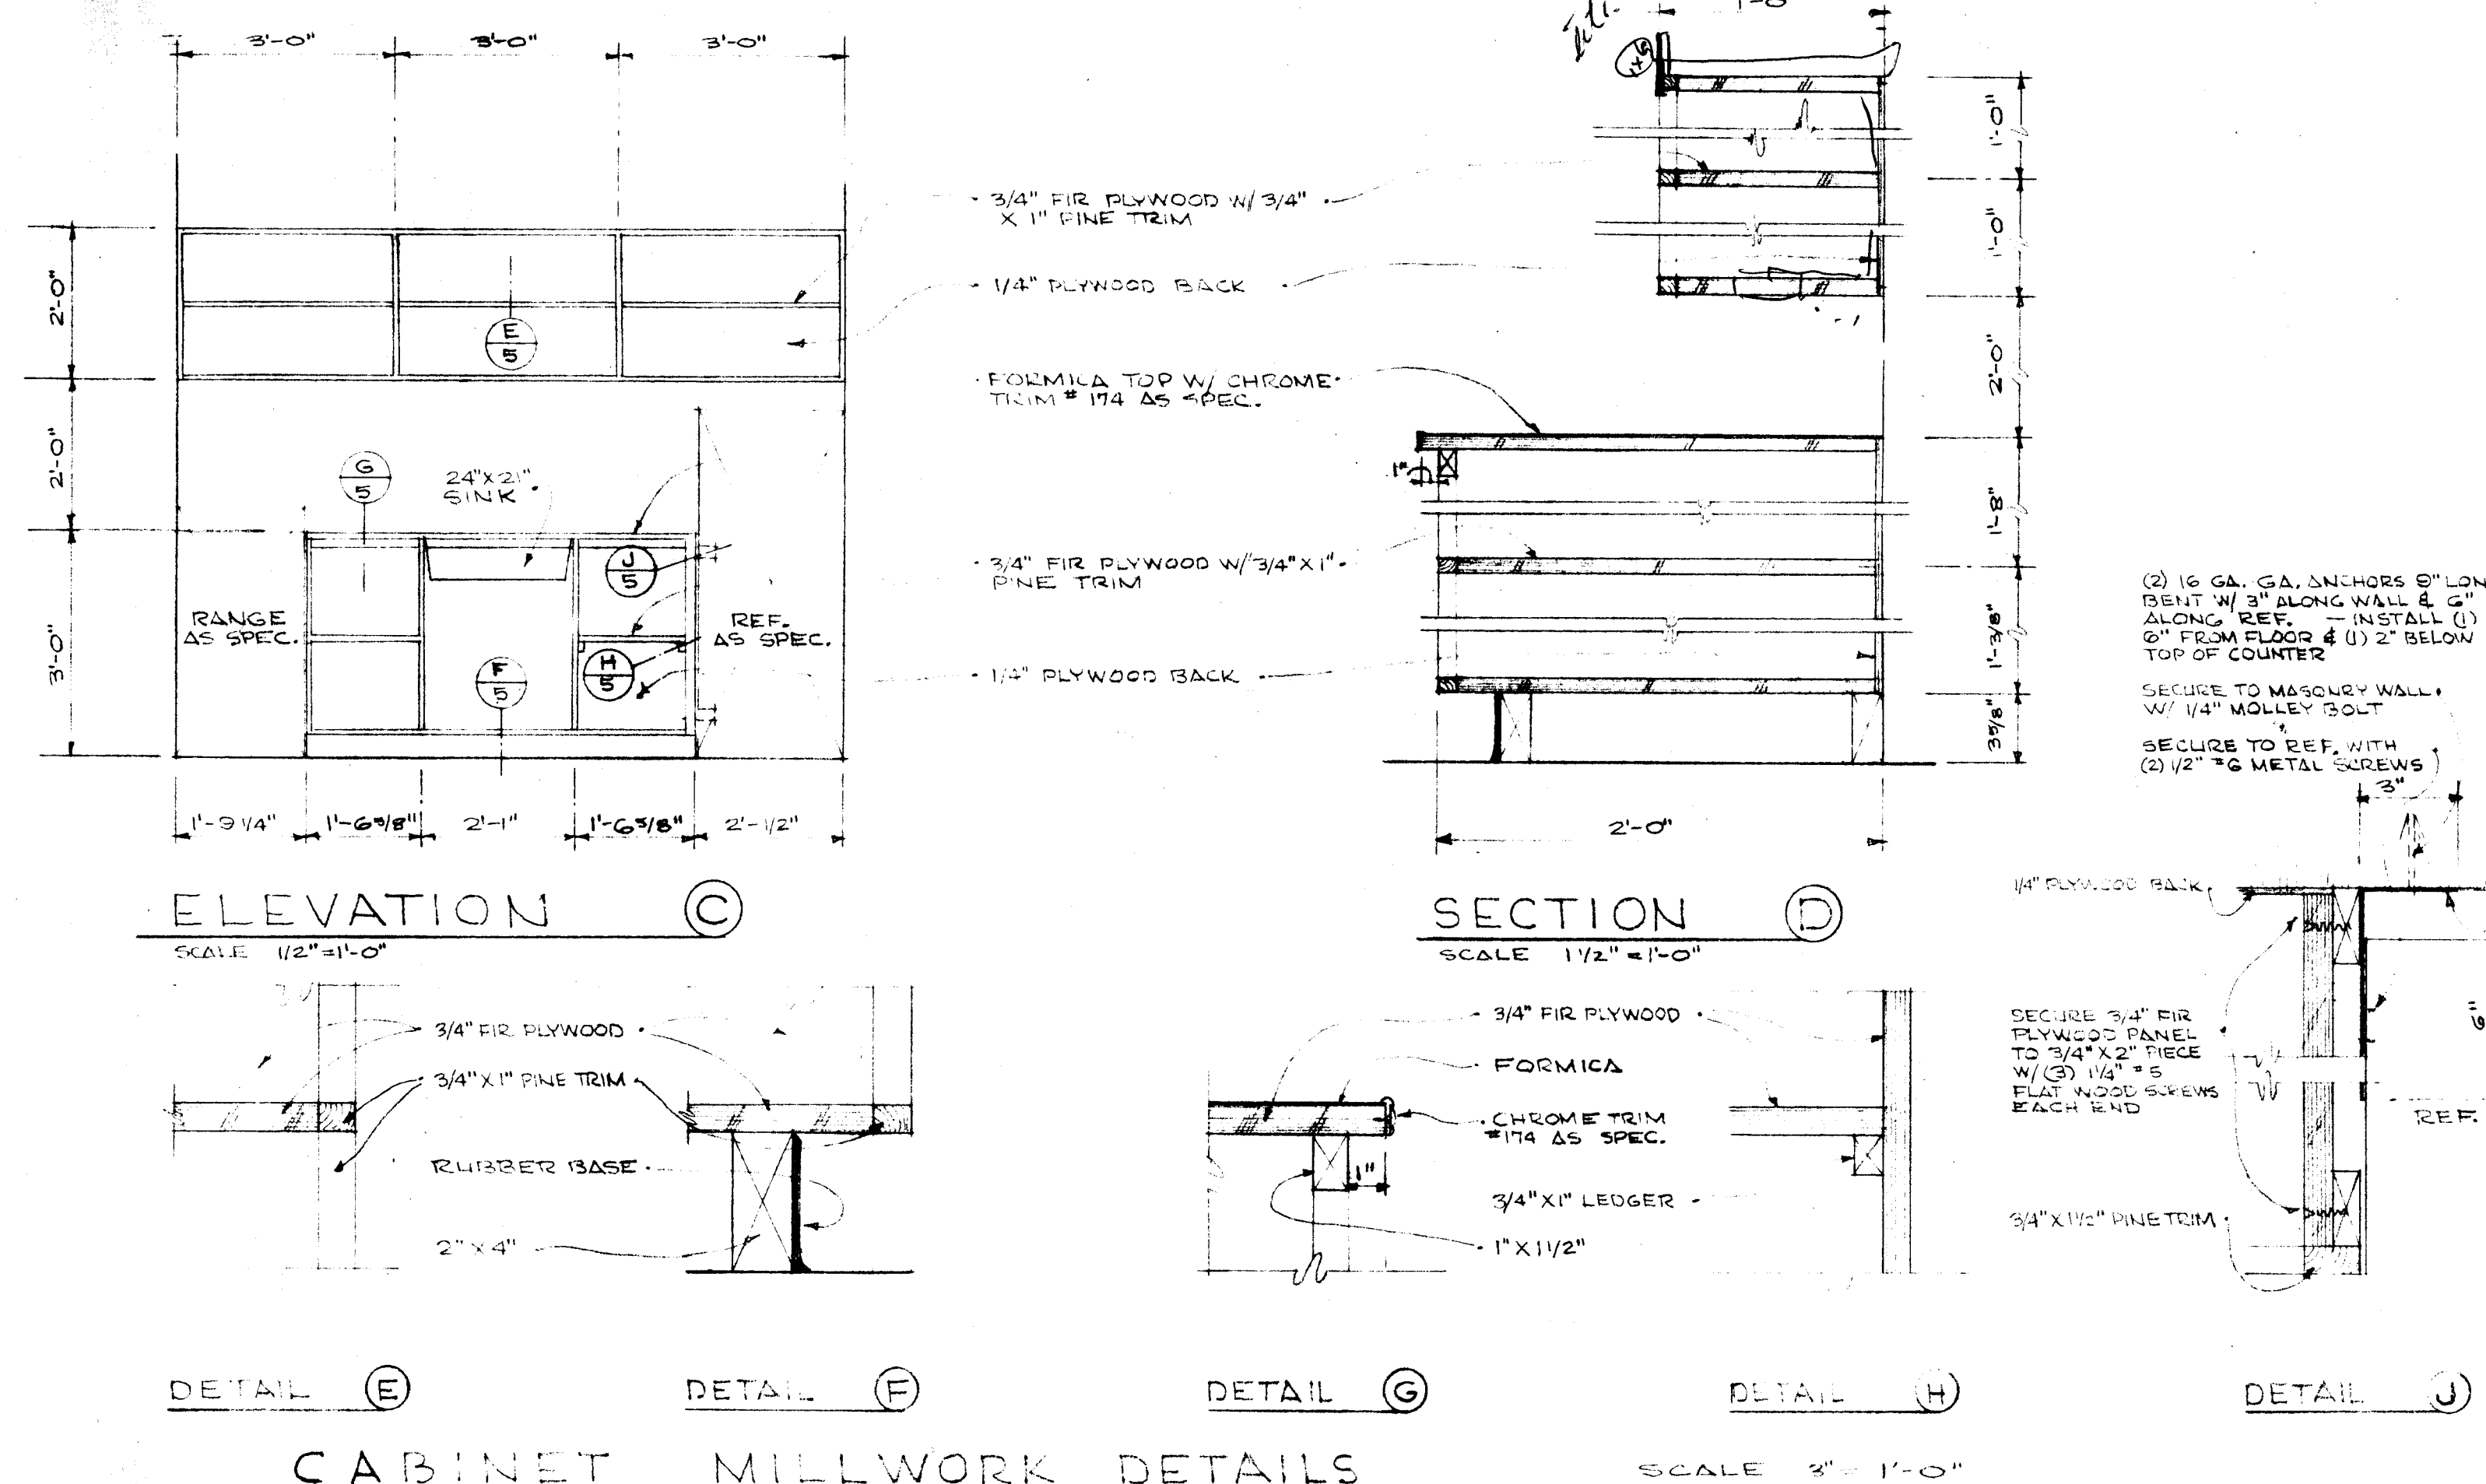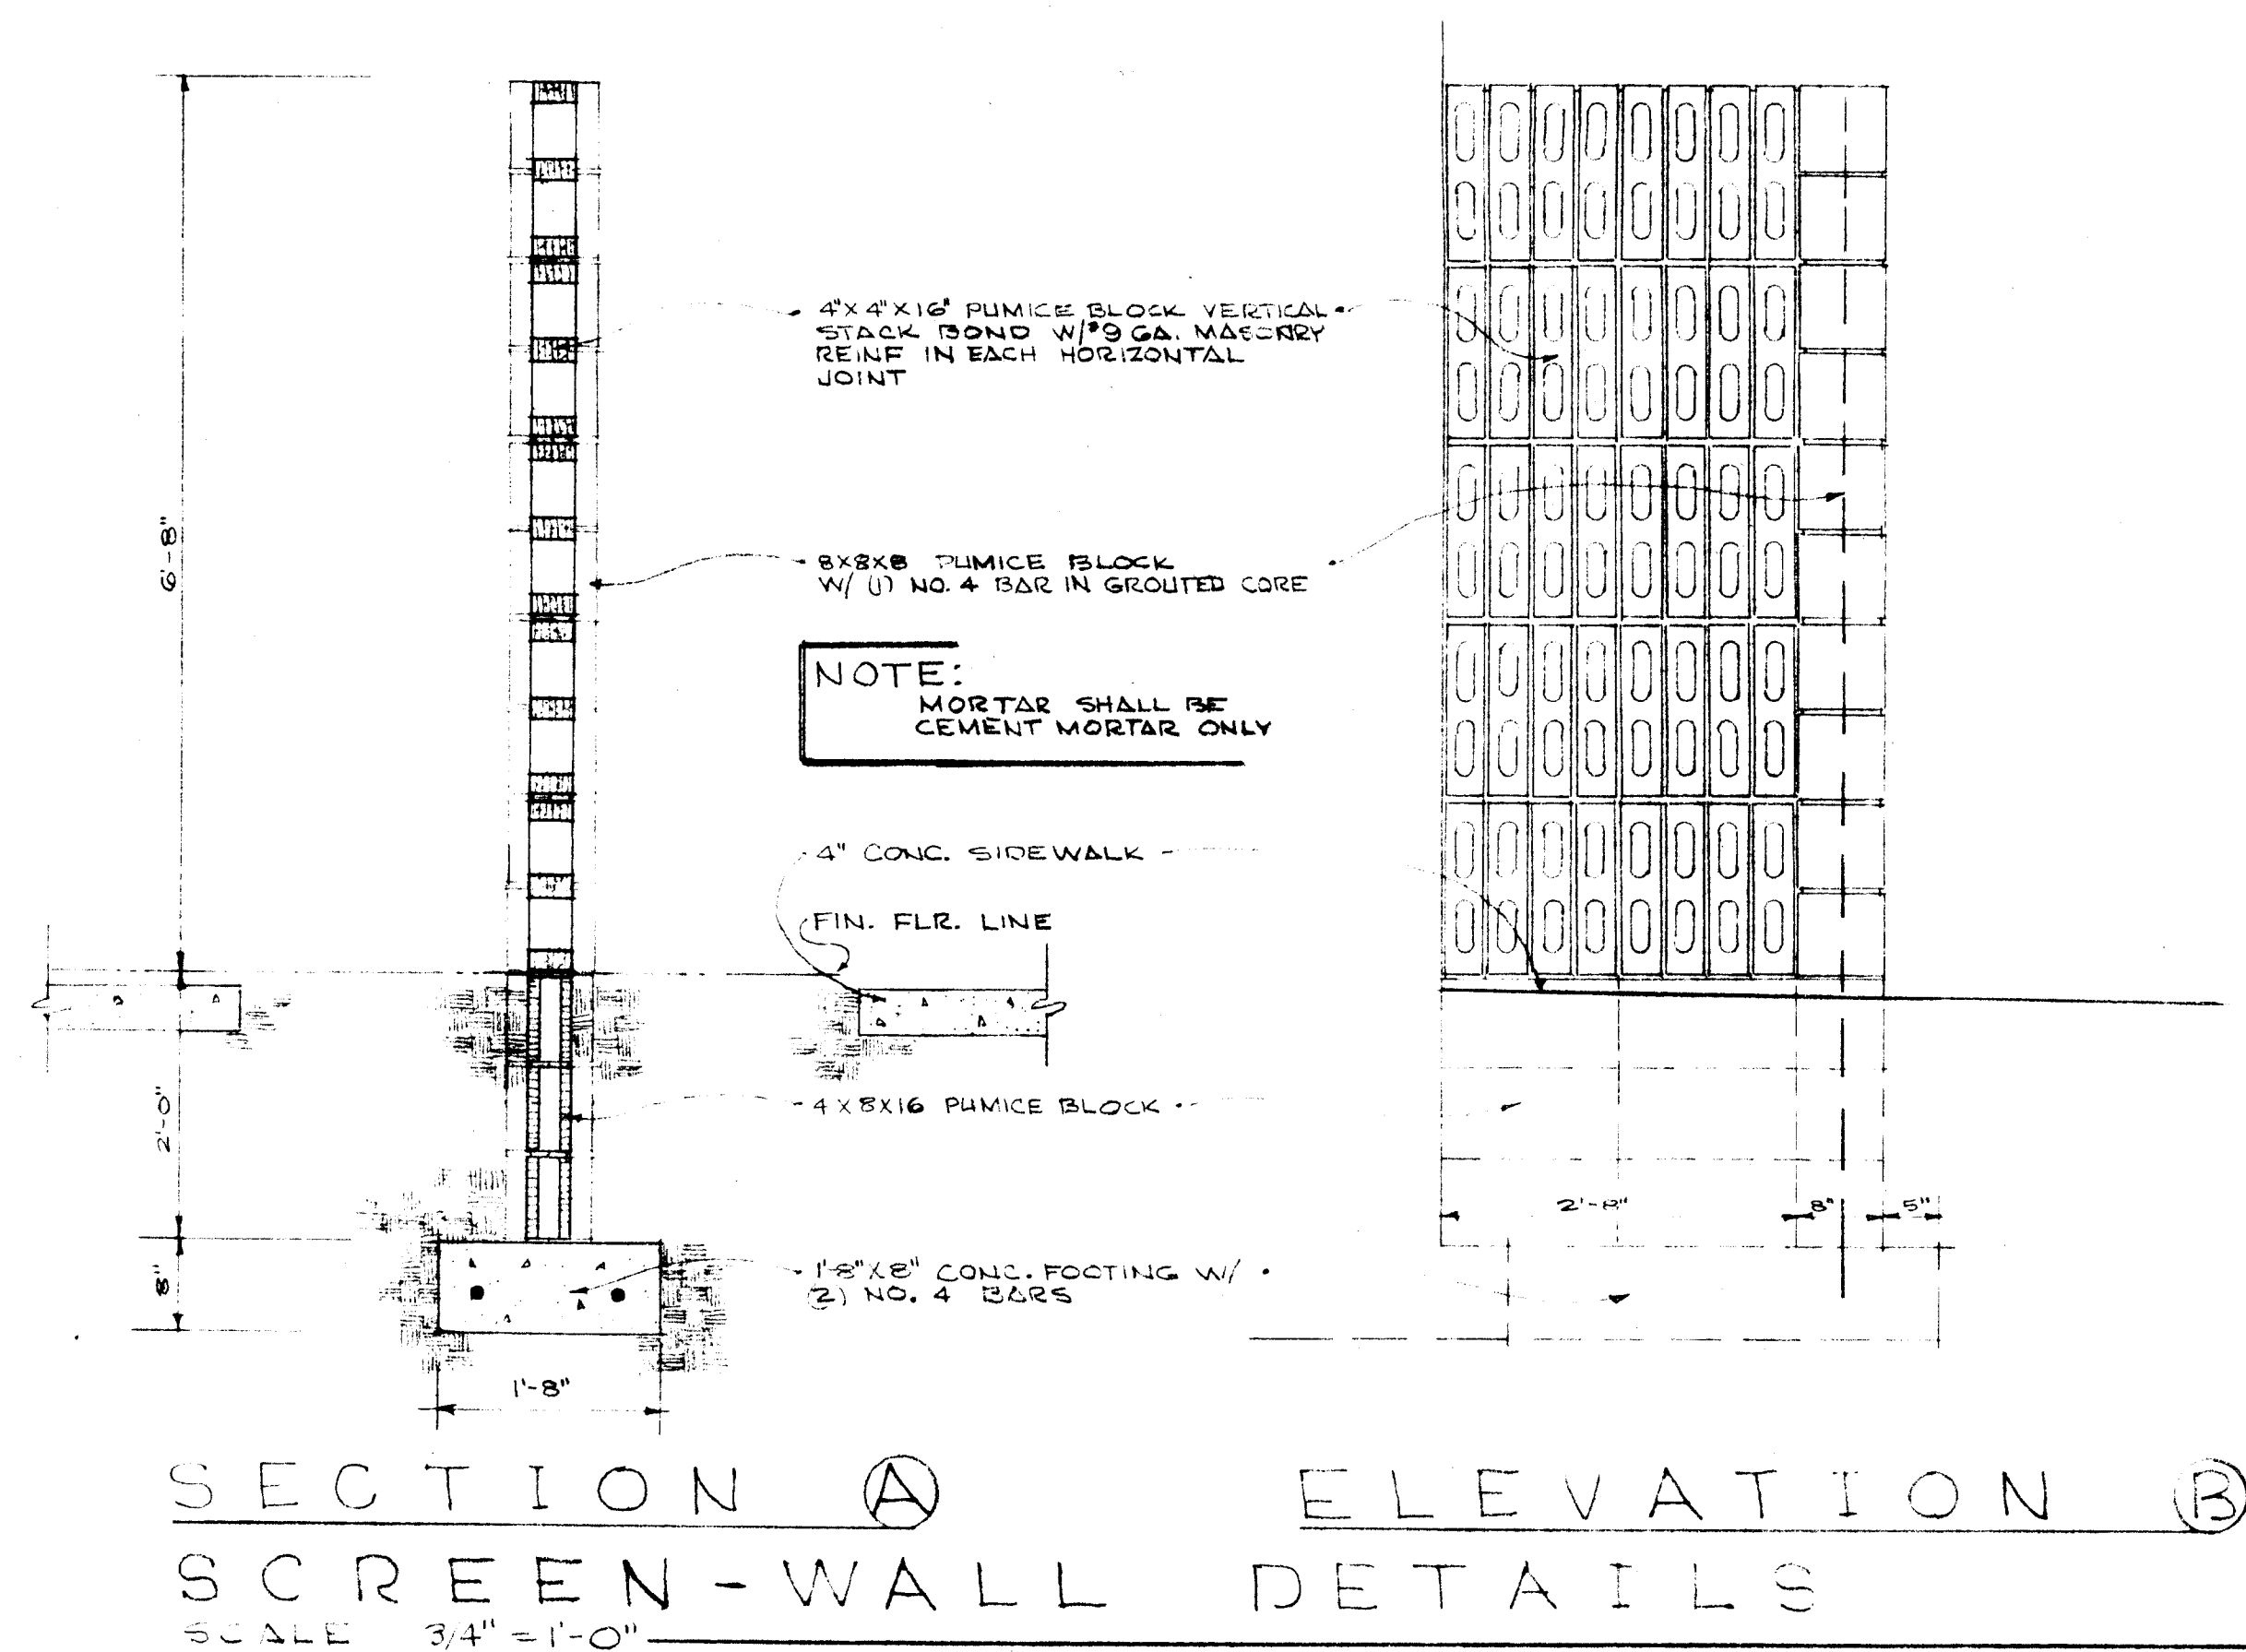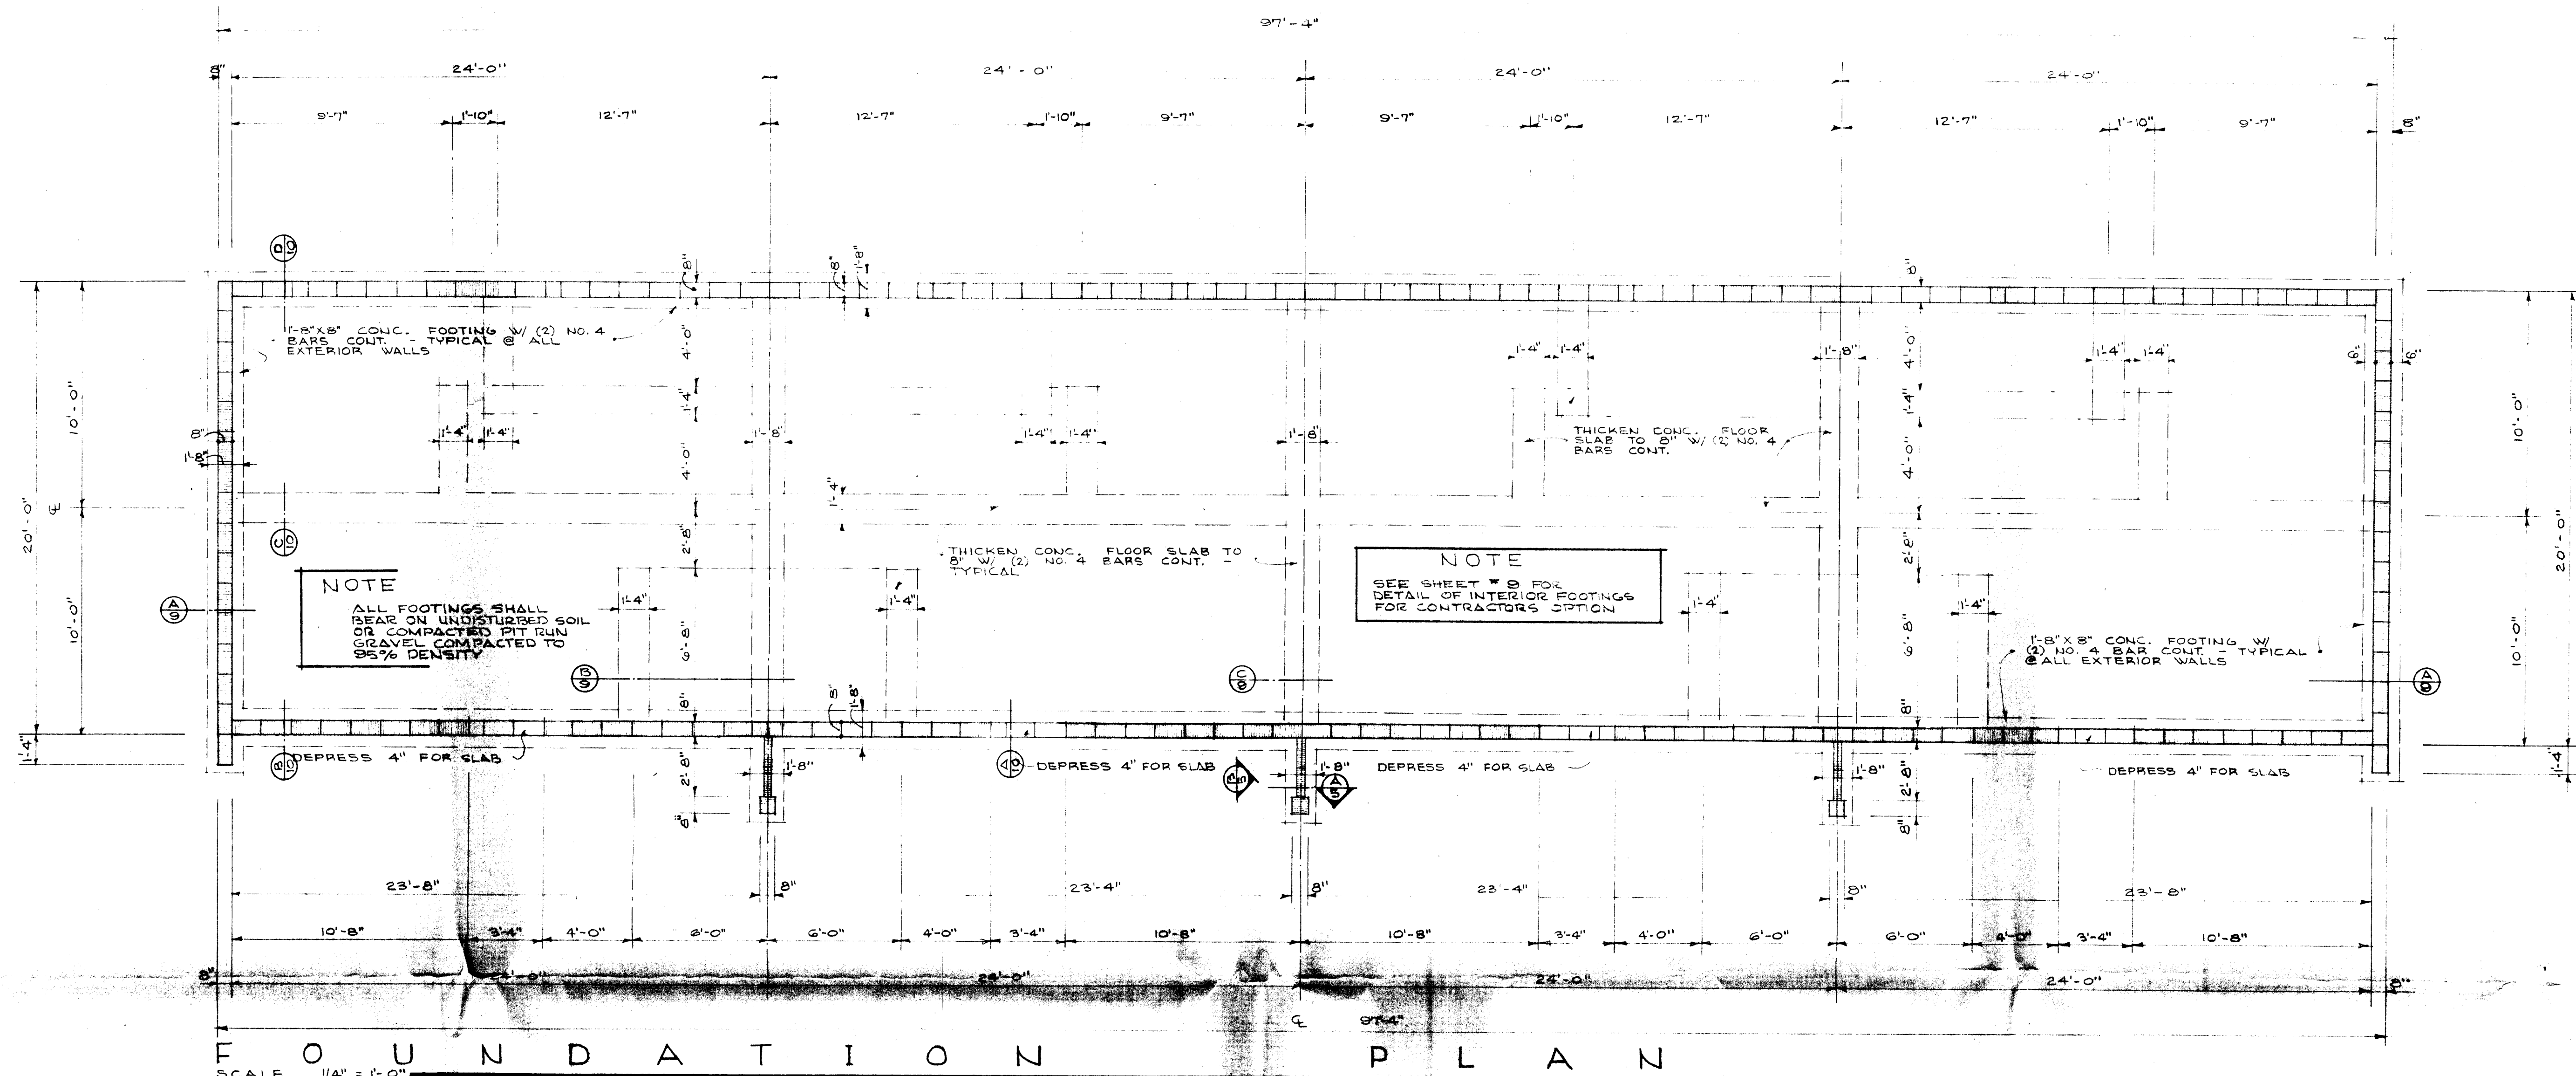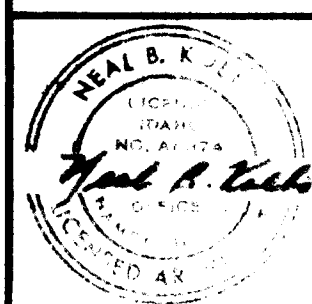

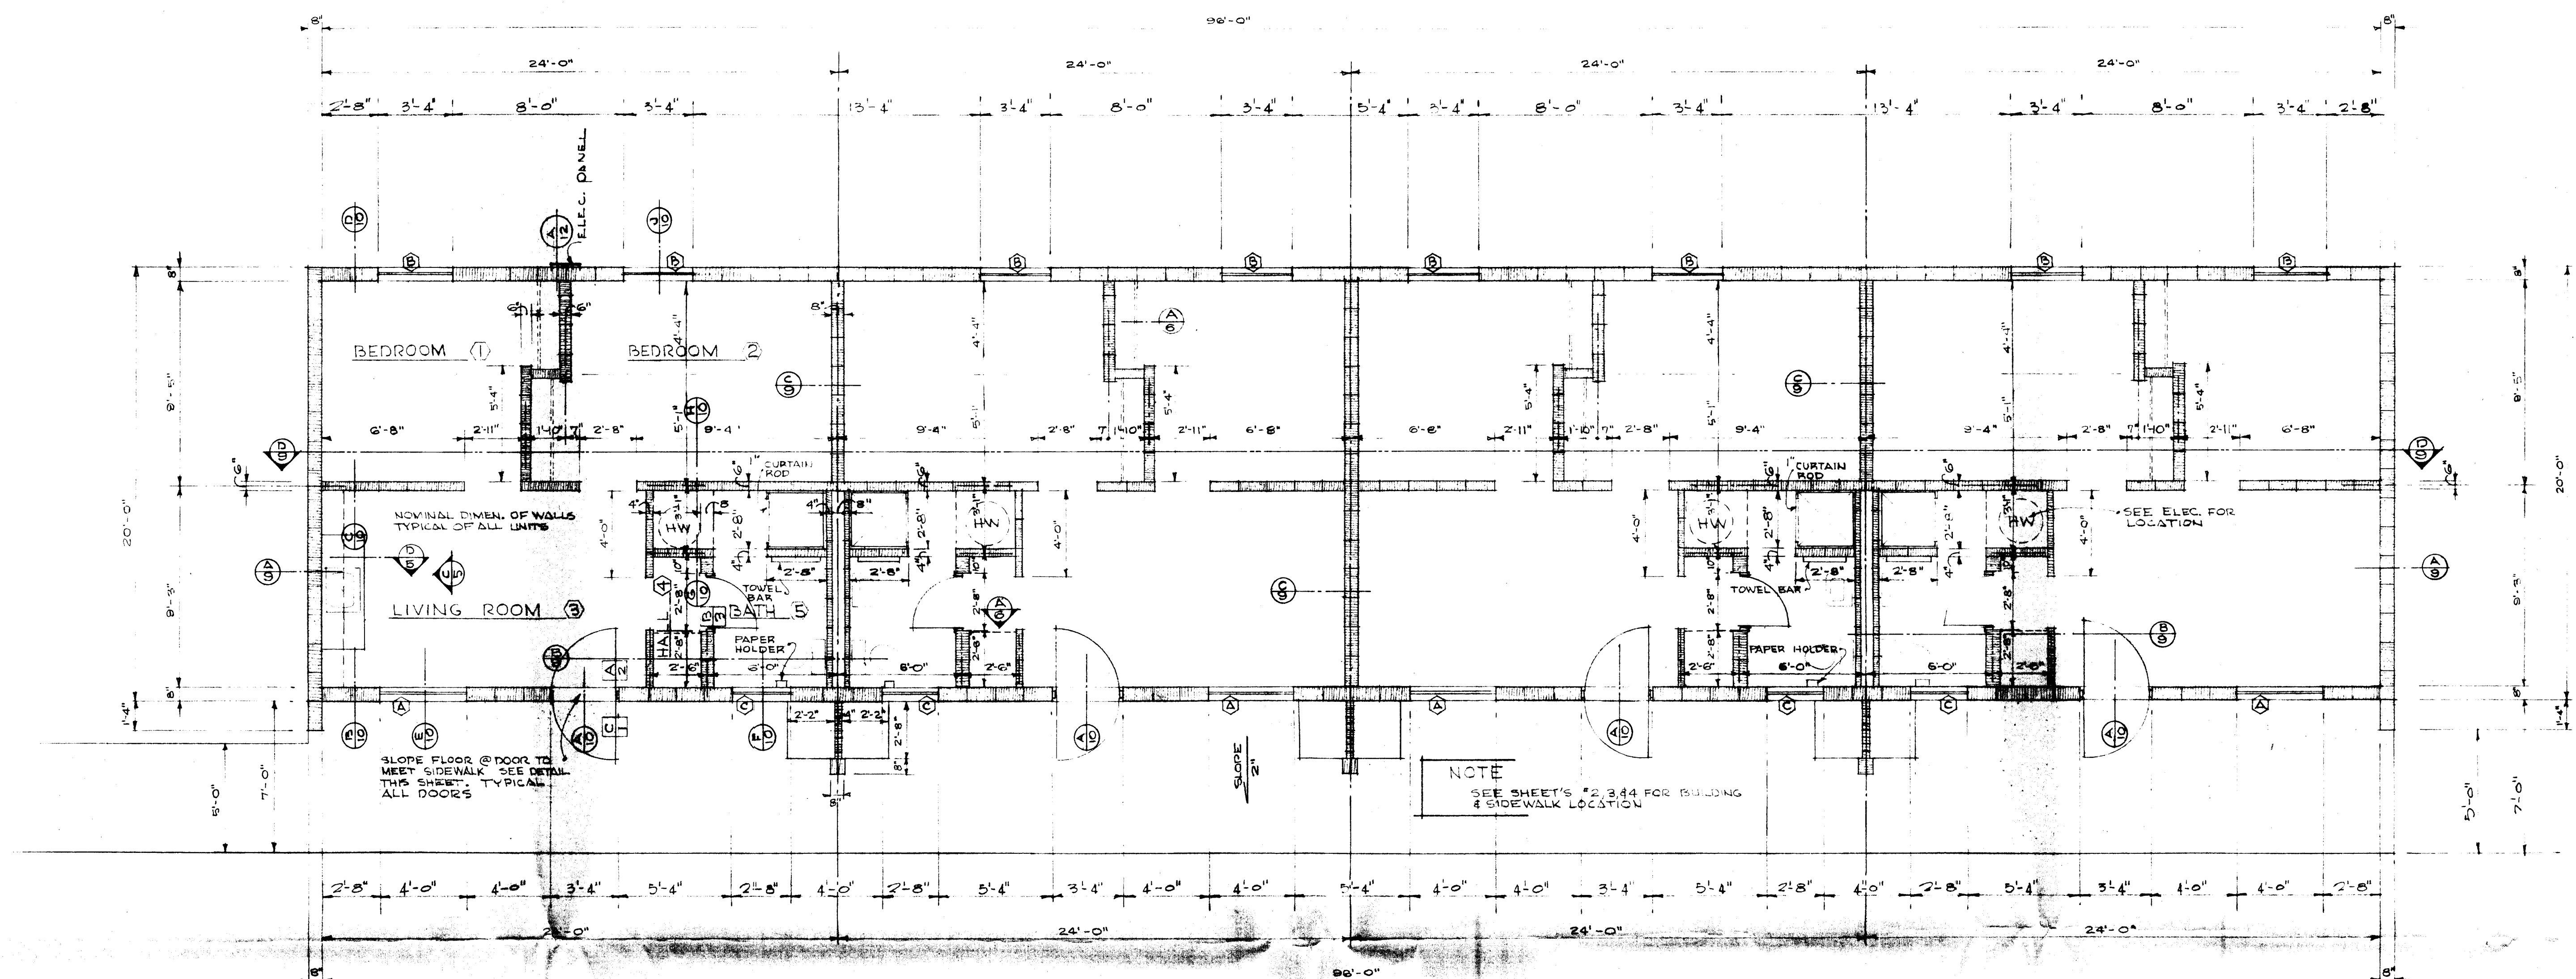


FLOOR PLAN

SCALE 1/4" = 1'-0"
TYPICAL ROW HOUSES 1 THRU 28 - SEE COMPLEX C, D & F OF SITE PLAN


NOTE: SEE SHEET NO. 1 FOR FINISH FLOOR ELEVATIONS

ROOM NO.	FLOORS	WALLS	CEILINGS	MILLWORK	REMARKS
1 BEDROOM	●	●	●	●	
2 BEDROOM	●	●	●	●	
3 LIVING ROOM	●	●	●	●	
4 HALL	●	●	●	●	
5 BATH	●	●	●	●	

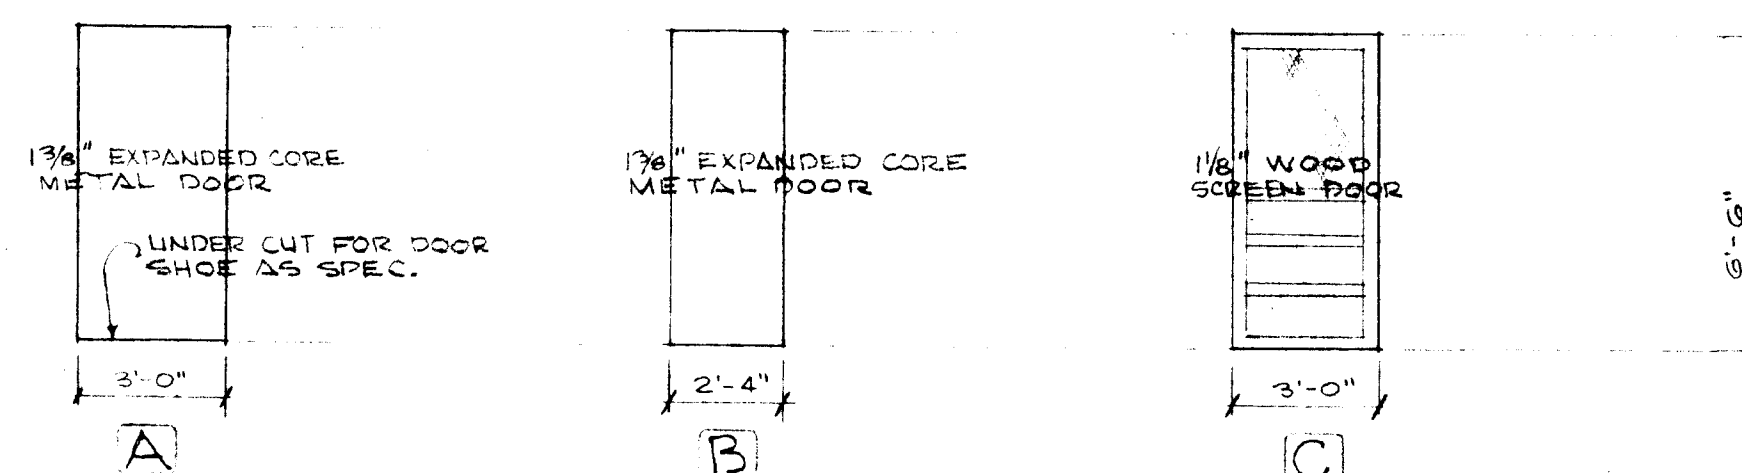


DOOR SCHEDULE

SCALE 3/4" = 1'-0"

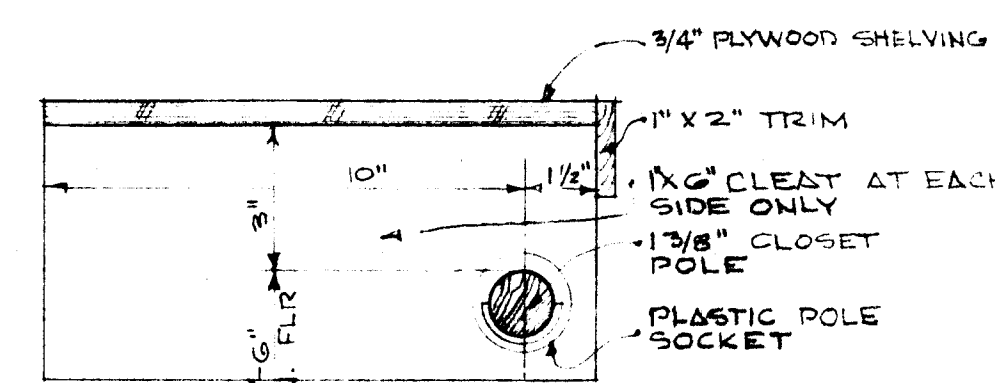

ROD & SHELF DETAIL (A)


SCALE 3/8" = 1'-0"

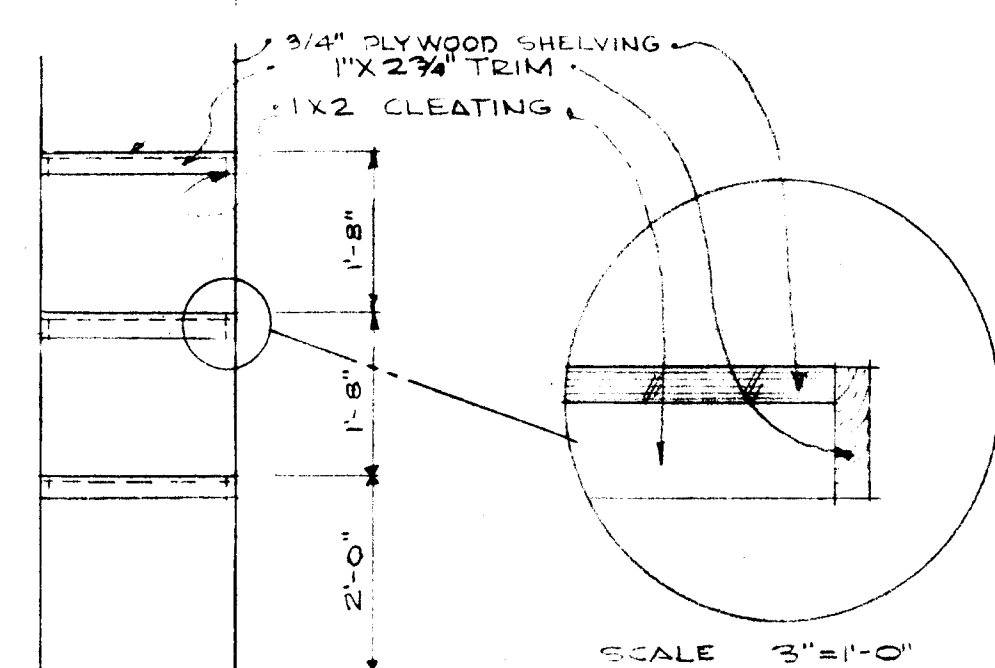

ELEVATION A

MILLWORK DETAILS

SCALE 1/2" = 1'-0"

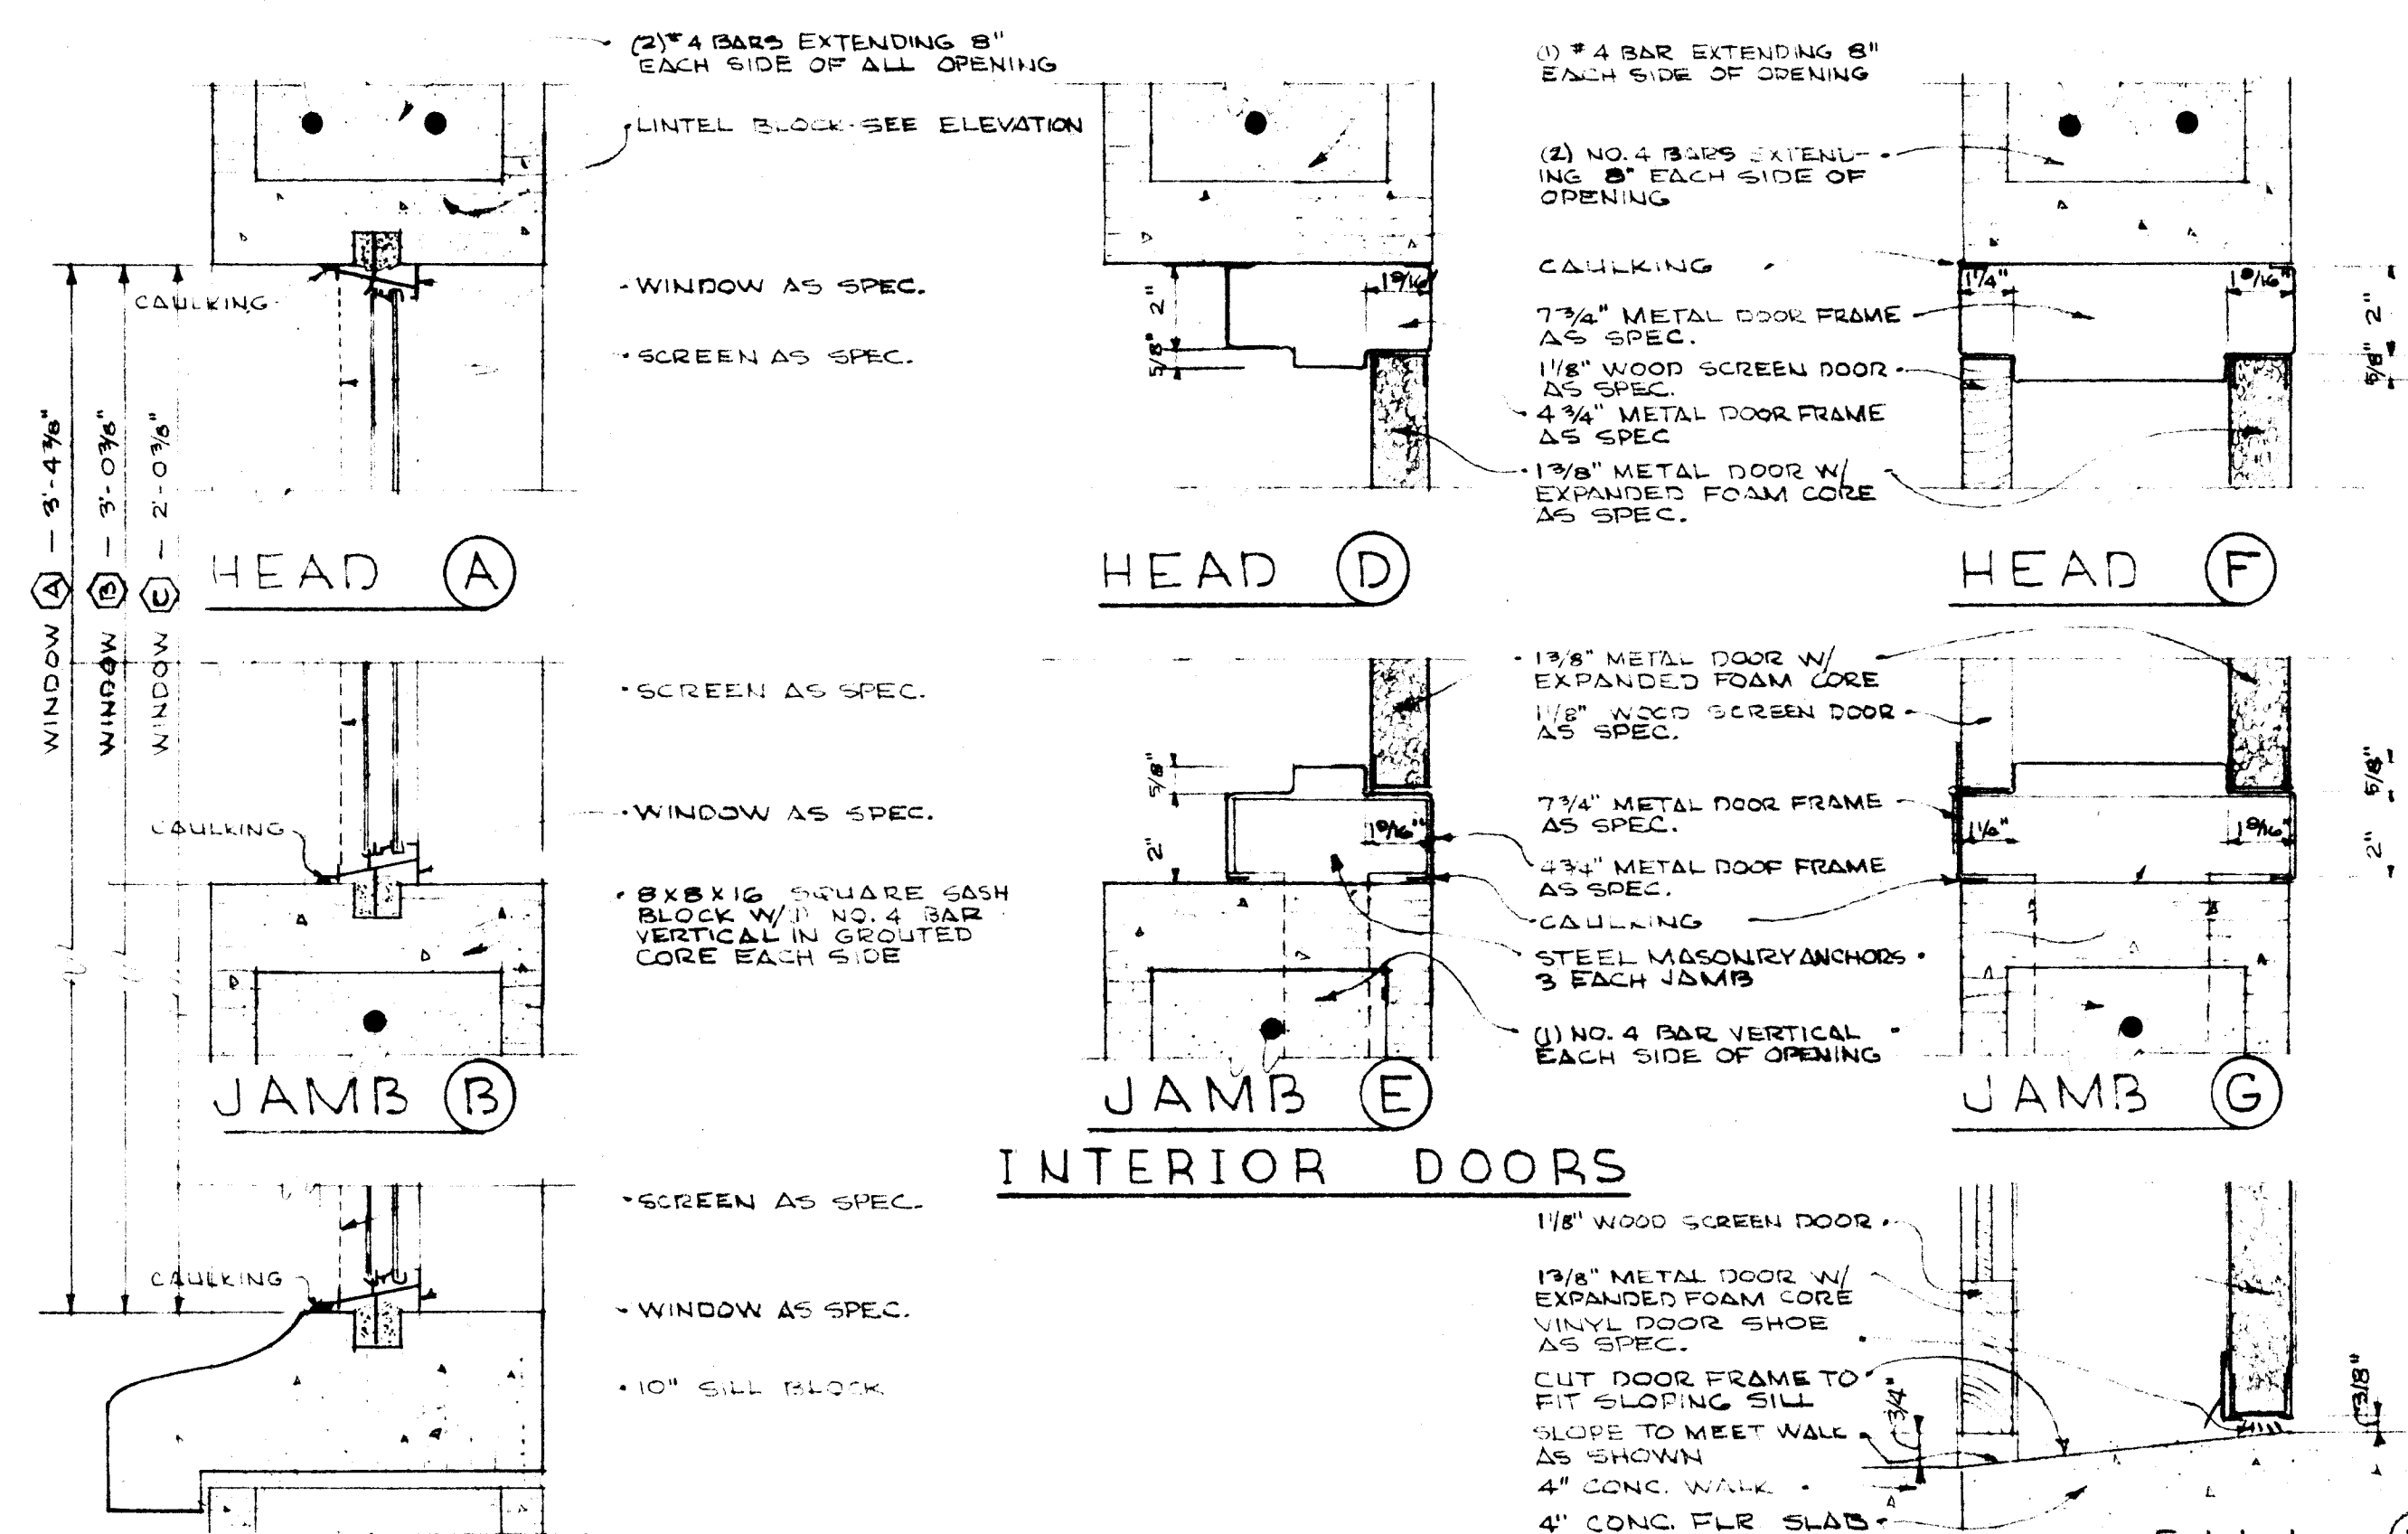

WINDOW DETAILS

SCALE 3/8" = 1'-0"

DOOR


SCALE 3/8" = 1'-0"

EXTERIOR DOORS

SCALE 3/8" = 1'-0"


THOMPSON & KOLBO Architects
A.I.A.
7071 FAIRVIEW AVENUE
717 ROOSEVELT AVENUE
BOISE, IDAHO
Nampa, IDAHO

FARM LABOR CAMP for
Caldwell Housing Authority
IDAHO
CANYON COUNTY,

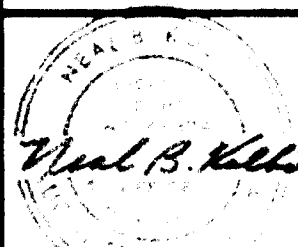


T K
DRAWN BY: WRS 25
DATE: 9-8-69
CHECKED: JHB
JOB NO.: 6916

SHEET NUMBER
A-6
3 OF 15

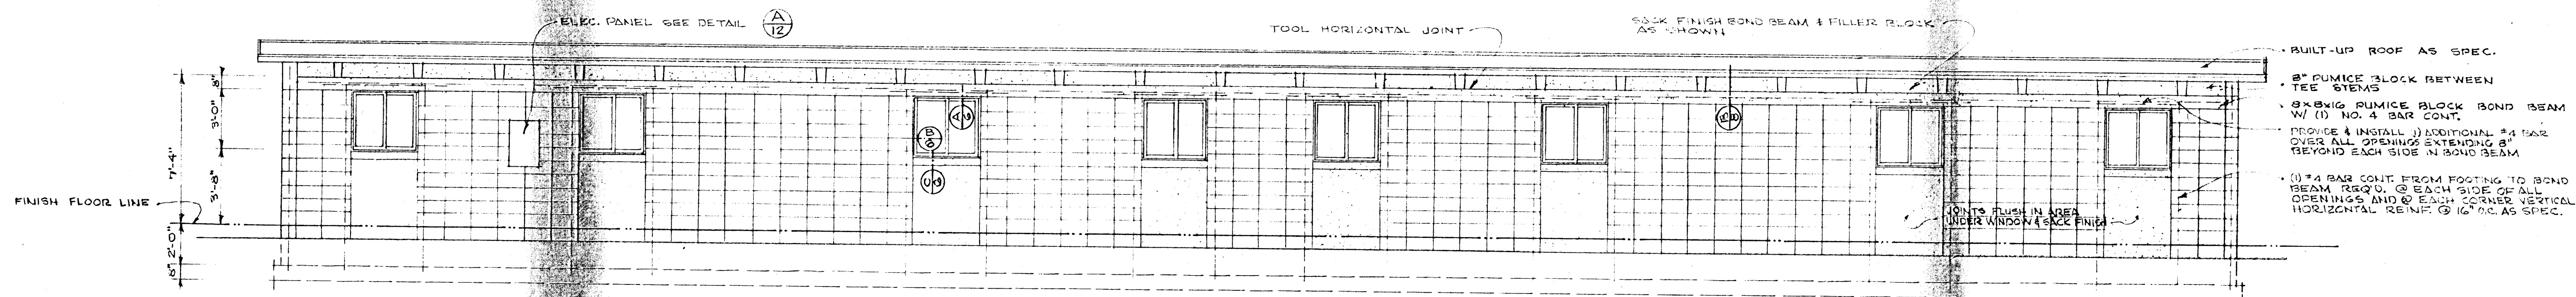

R E A R E L E V A T I O N

SCALE 1/4" = 1'-0"

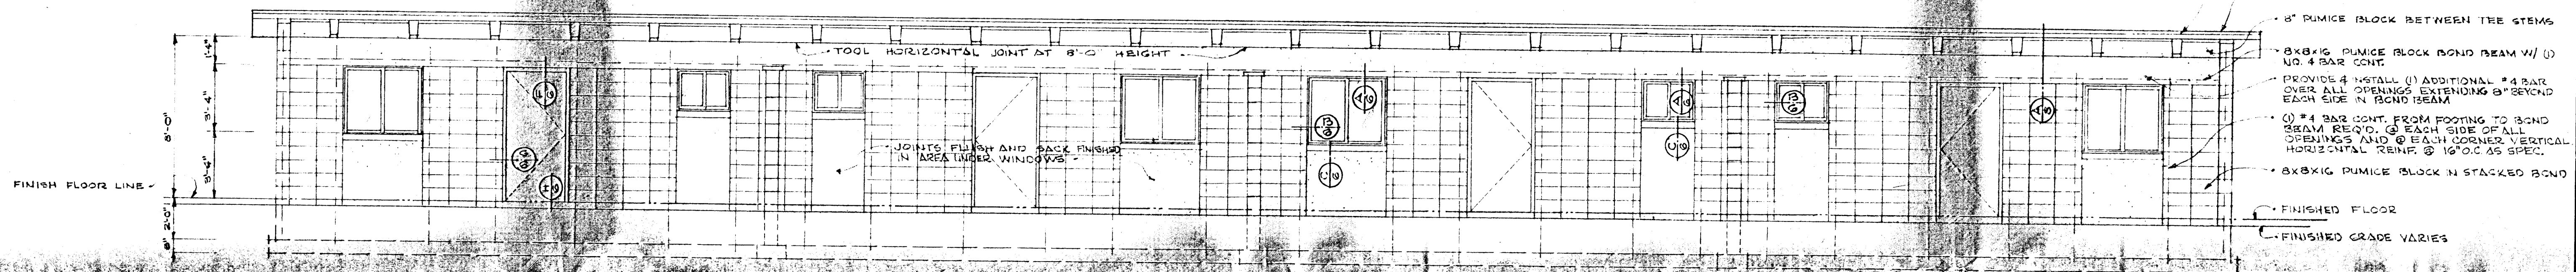


F R O N T E L E V A T I O N

SCALE 1/4" = 1'-0"


NOTE:

FINISH FLOOR ELEVATION - SEE SHEET #1
TOP OF ALL FOOTINGS 2'-0" BELOW FINISH FLOOR

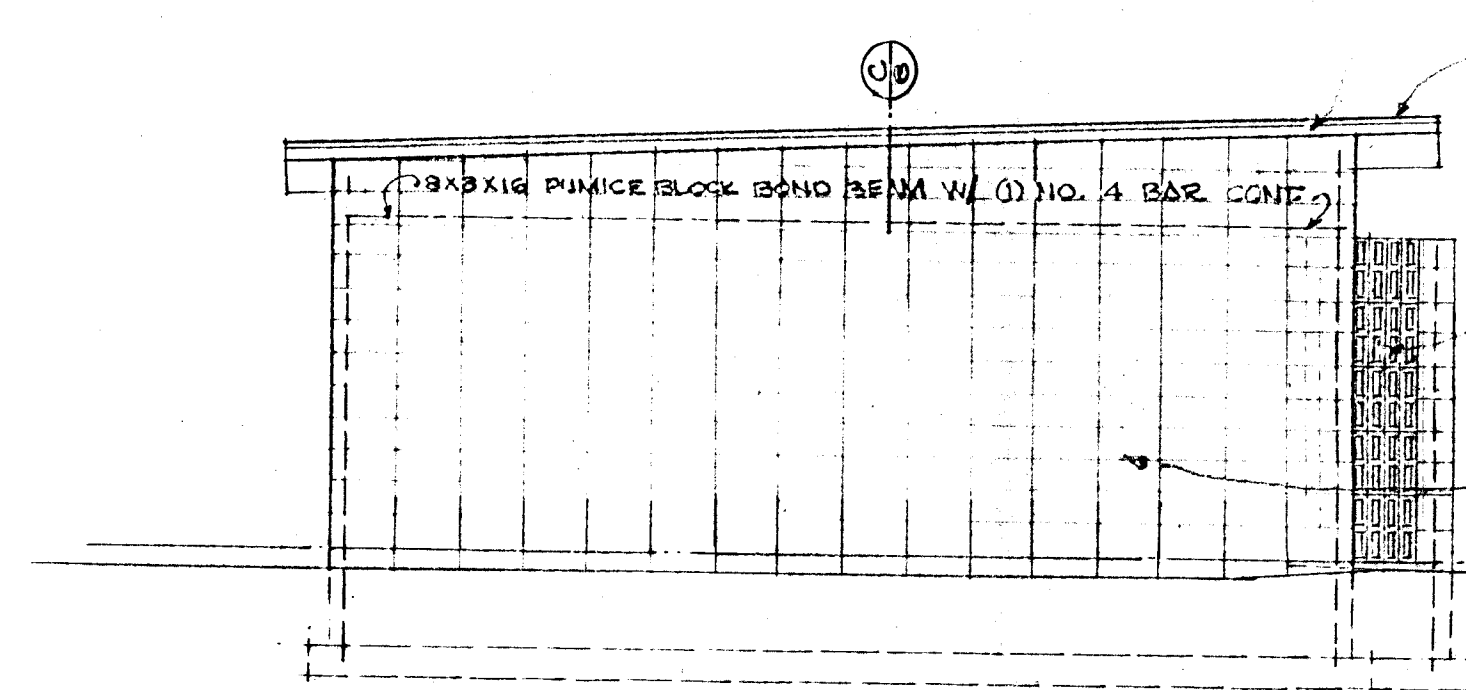


L E F T E L E V A T I O N

SCALE 1/4" = 1'-0"

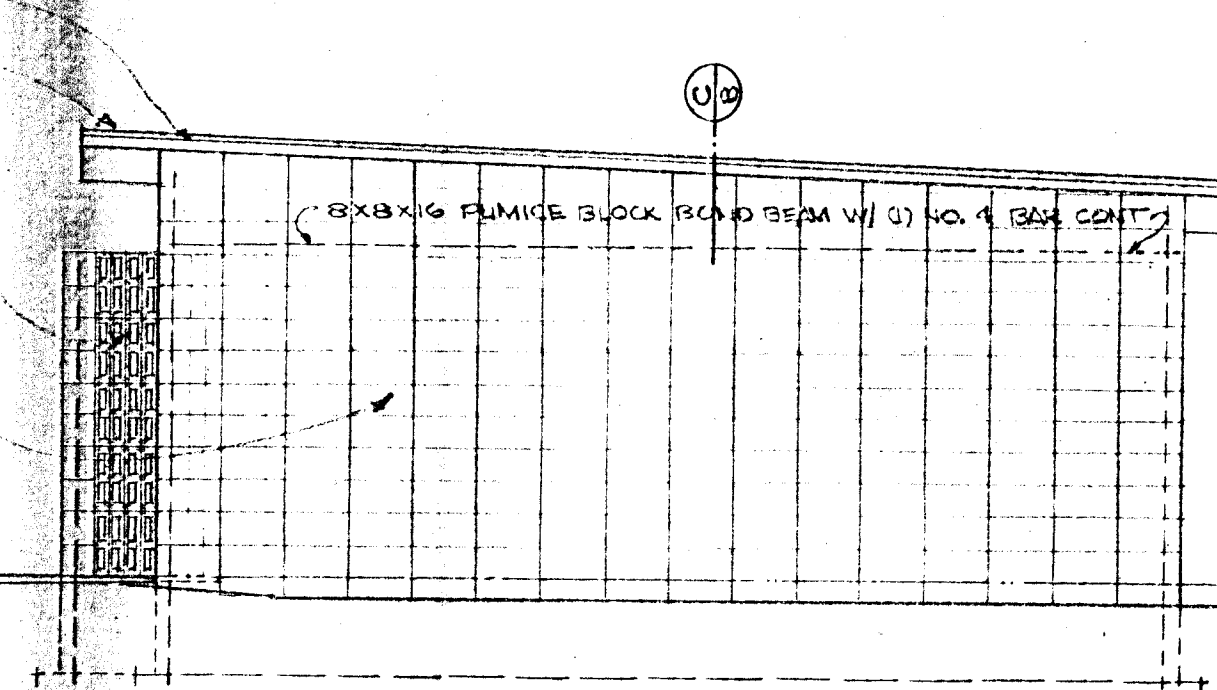


R I G H T E L E V A T I O N

SCALE 1/4" = 1'-0"

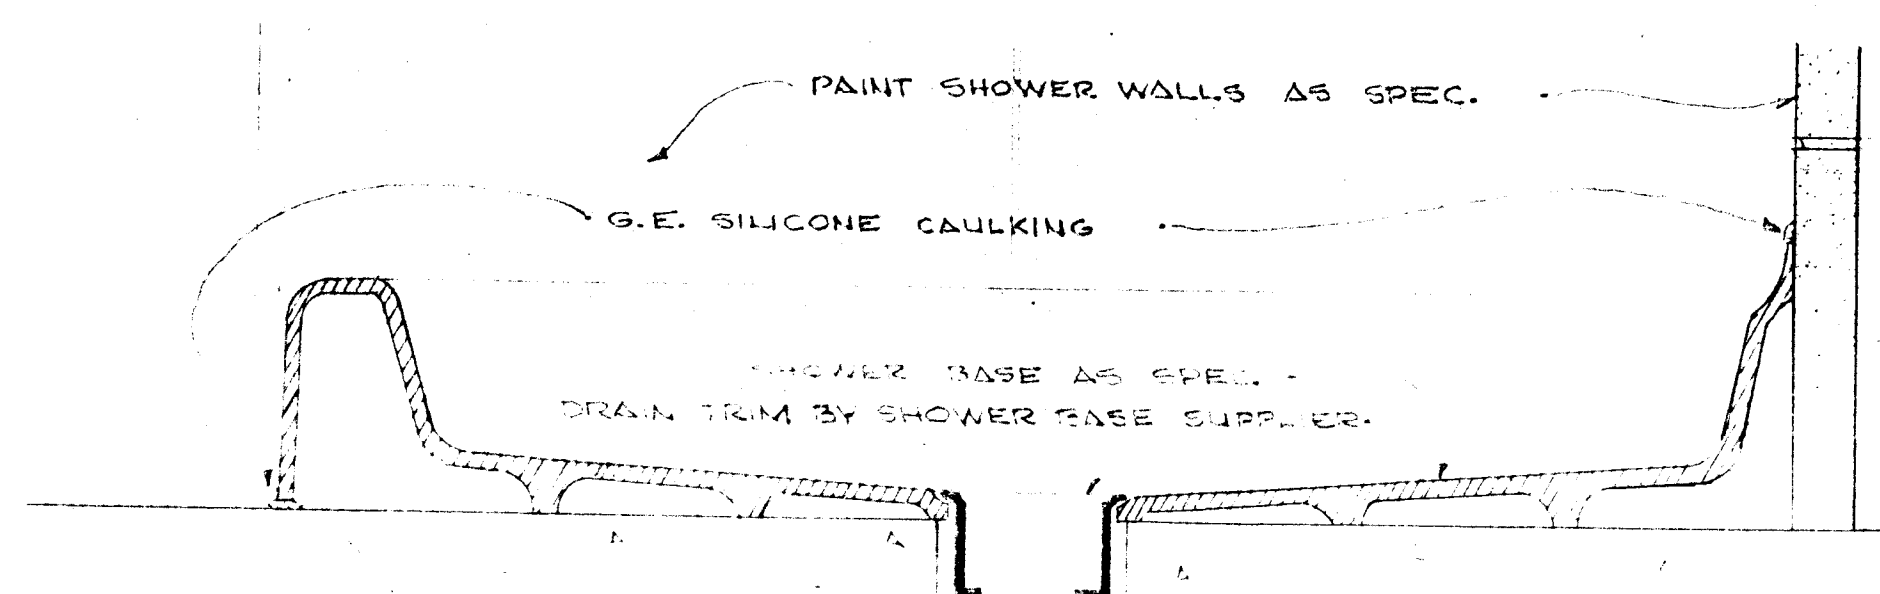


S H O W E R B A S E D E T A I L A

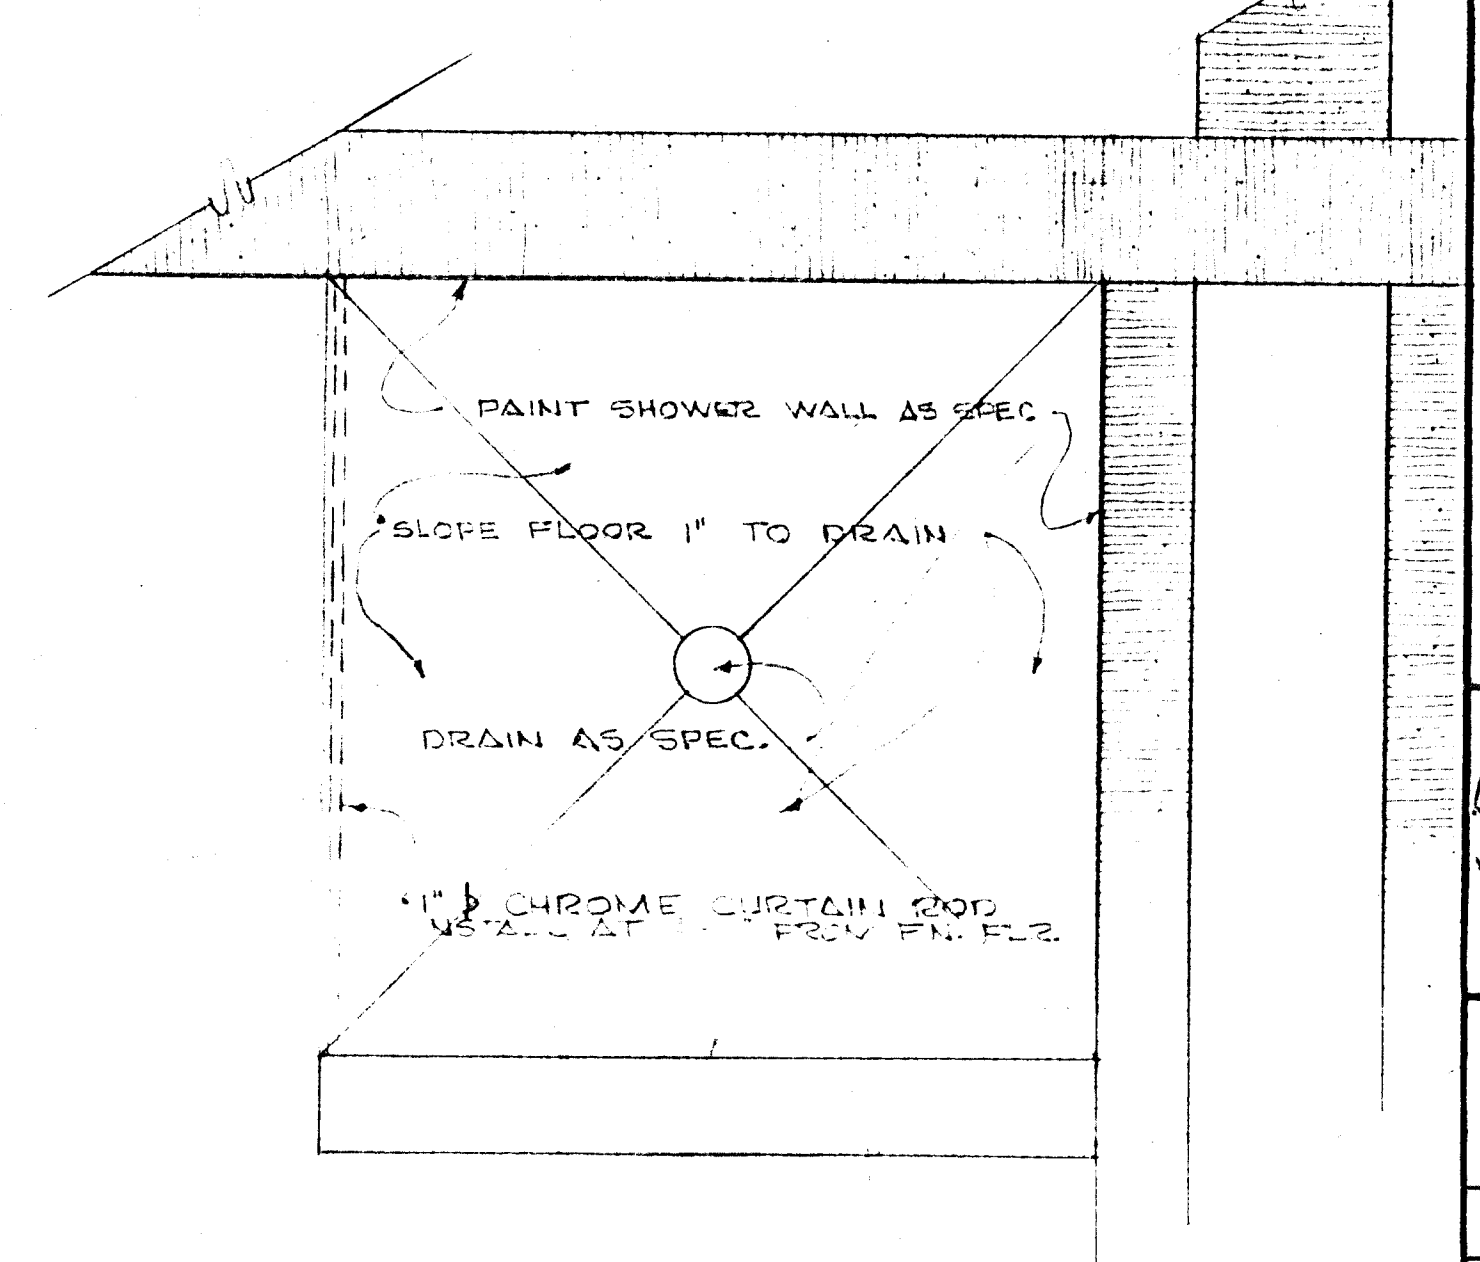

S H O W E R A L T E R N A T E # 1

THOMPSON & KOLBO Architects
A-I-A
7071 FAIRVIEW AVENUE
717 ROOSEVELT AVENUE
BOISE, IDAHO
Nampa, IDAHO


for
FARM LABOR CAMP
CALDWELL HOUSING AUTHORITY
IDAHO
CANYON COUNTY,

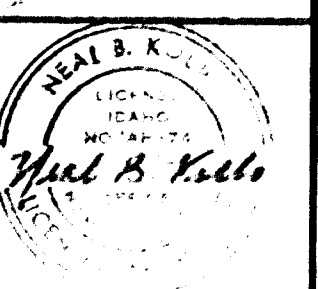

T
K


DRAWN BY: DATE: 3-3-58
CHECKED: JOB NO. 001

SHEET NUMBER
A-7
7 OF 13

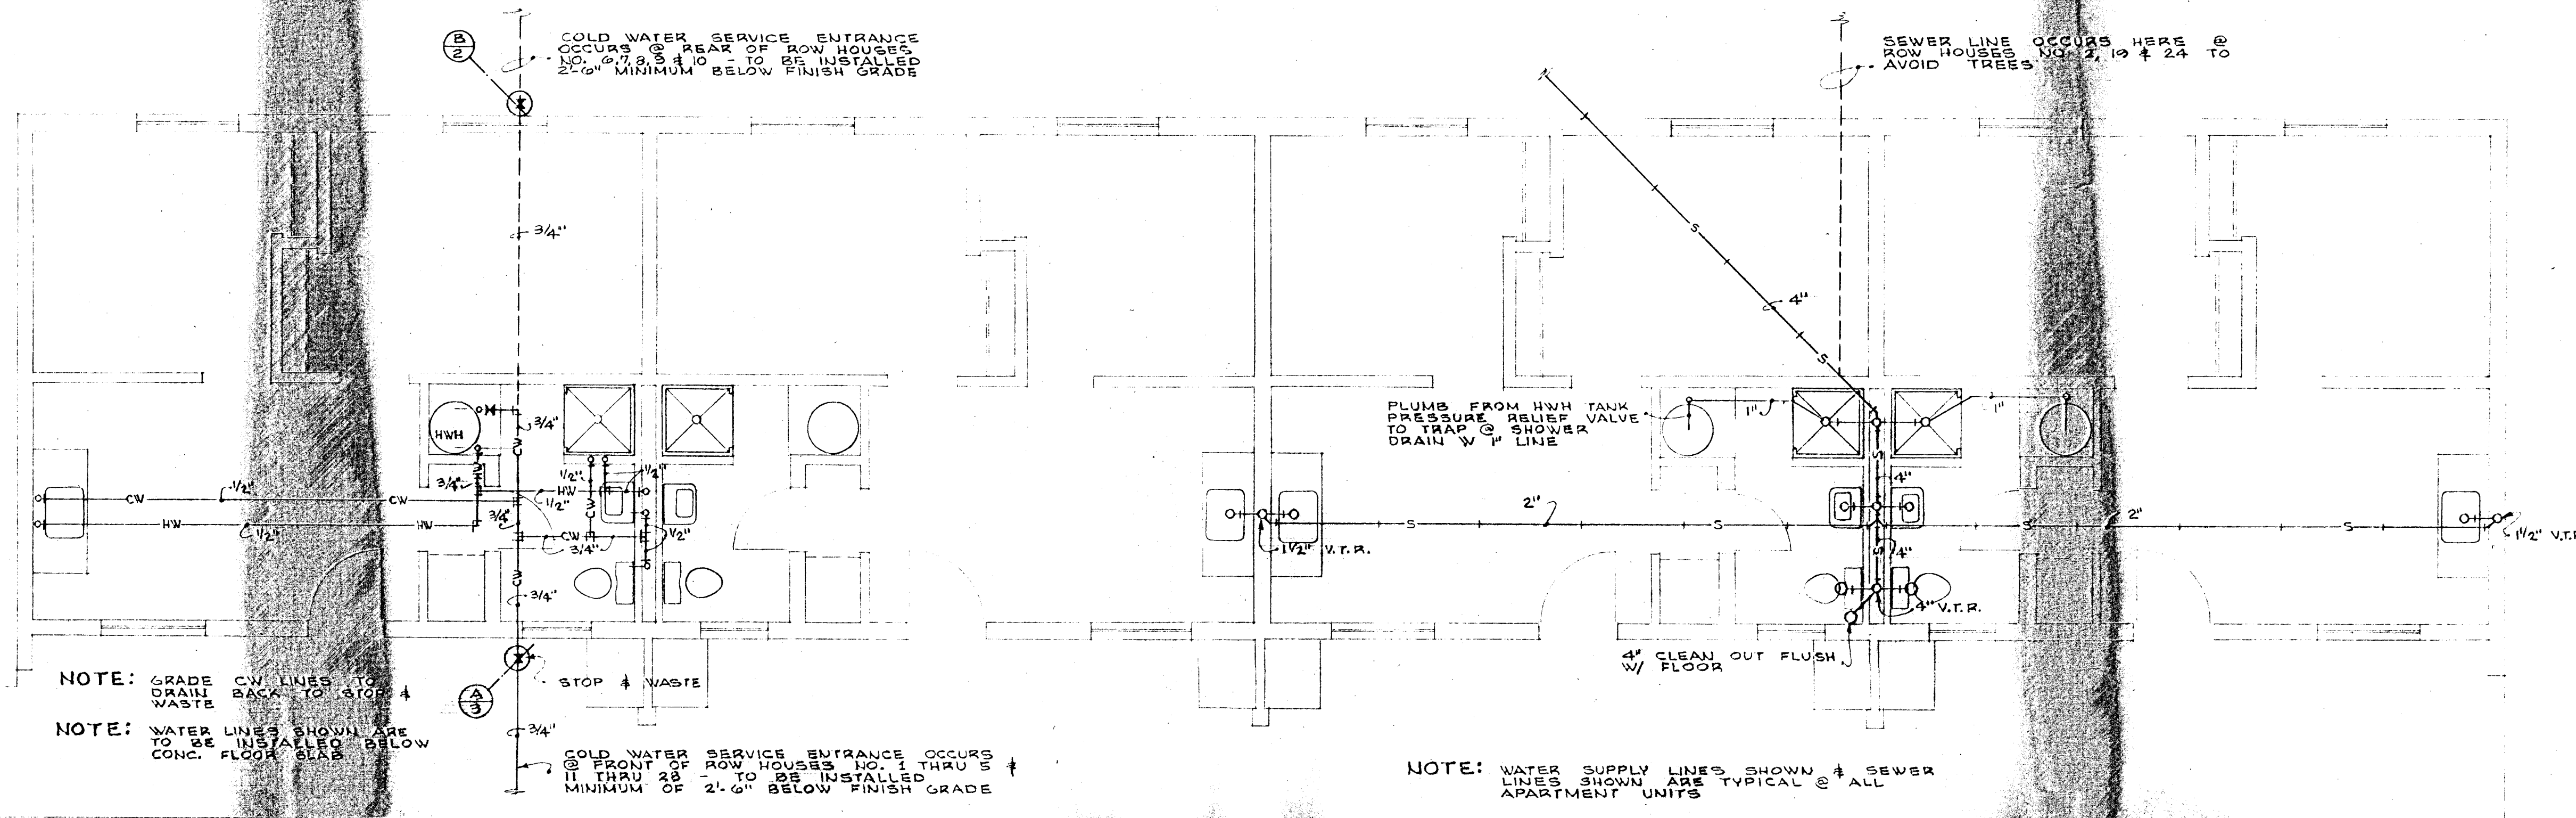


PLUMBING SUPPLY LAYOUT
TYPICAL @ ROW HOUSES NO. 1 THRU 5
SCALE 1/4" = 1'-0"


PLUMBING WASTE LAYOUT
TYPICAL @ ROW HOUSES NO. 1 THRU 5 & 11 THRU 20
SCALE 1/4" = 1'-0"

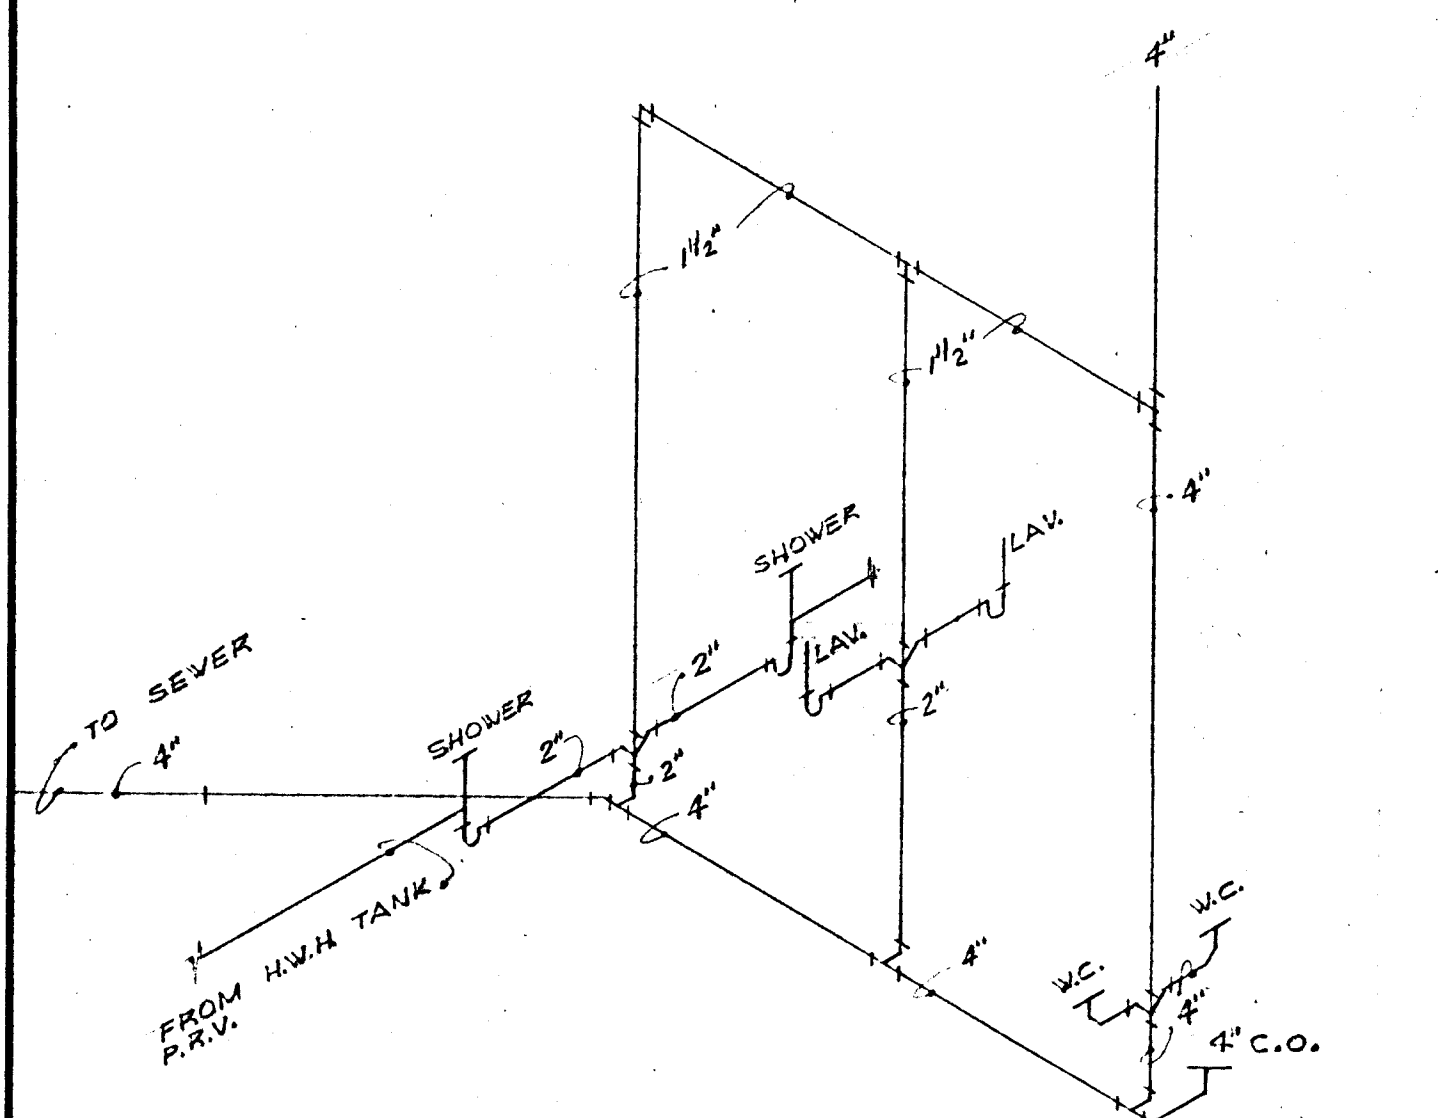

RISER DIAGRAM
NO SCALE

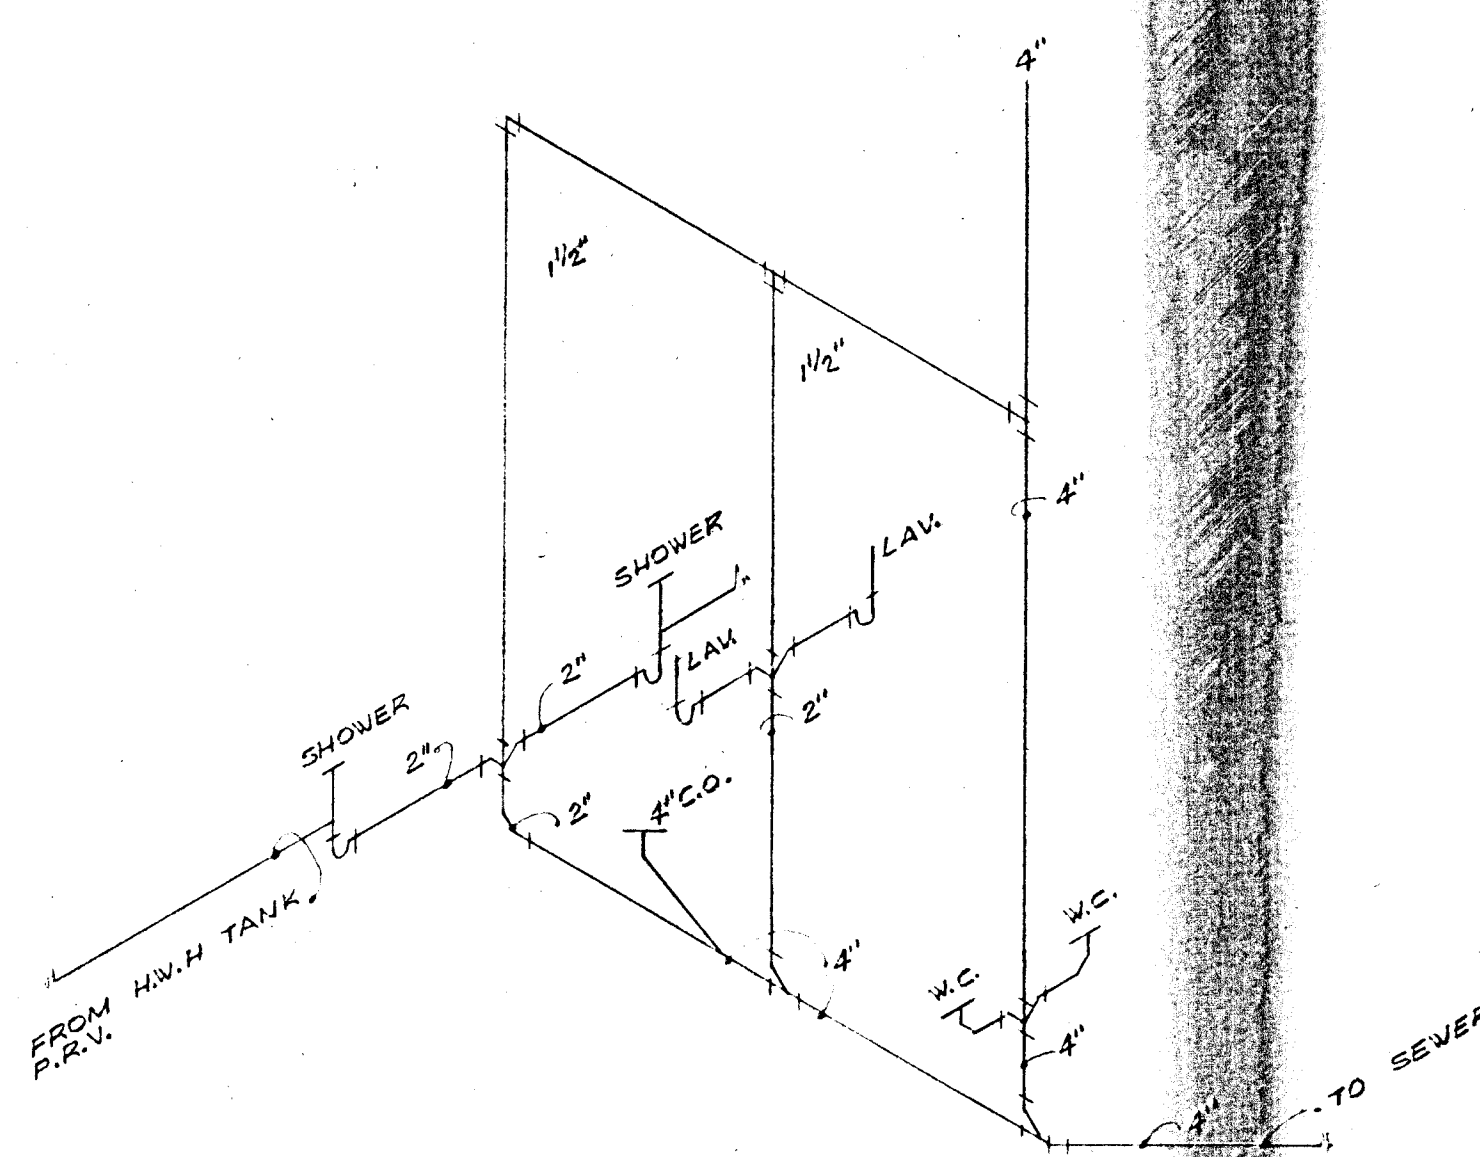

ALTERNATE "B"
RISER DIAGRAM
NO SCALE

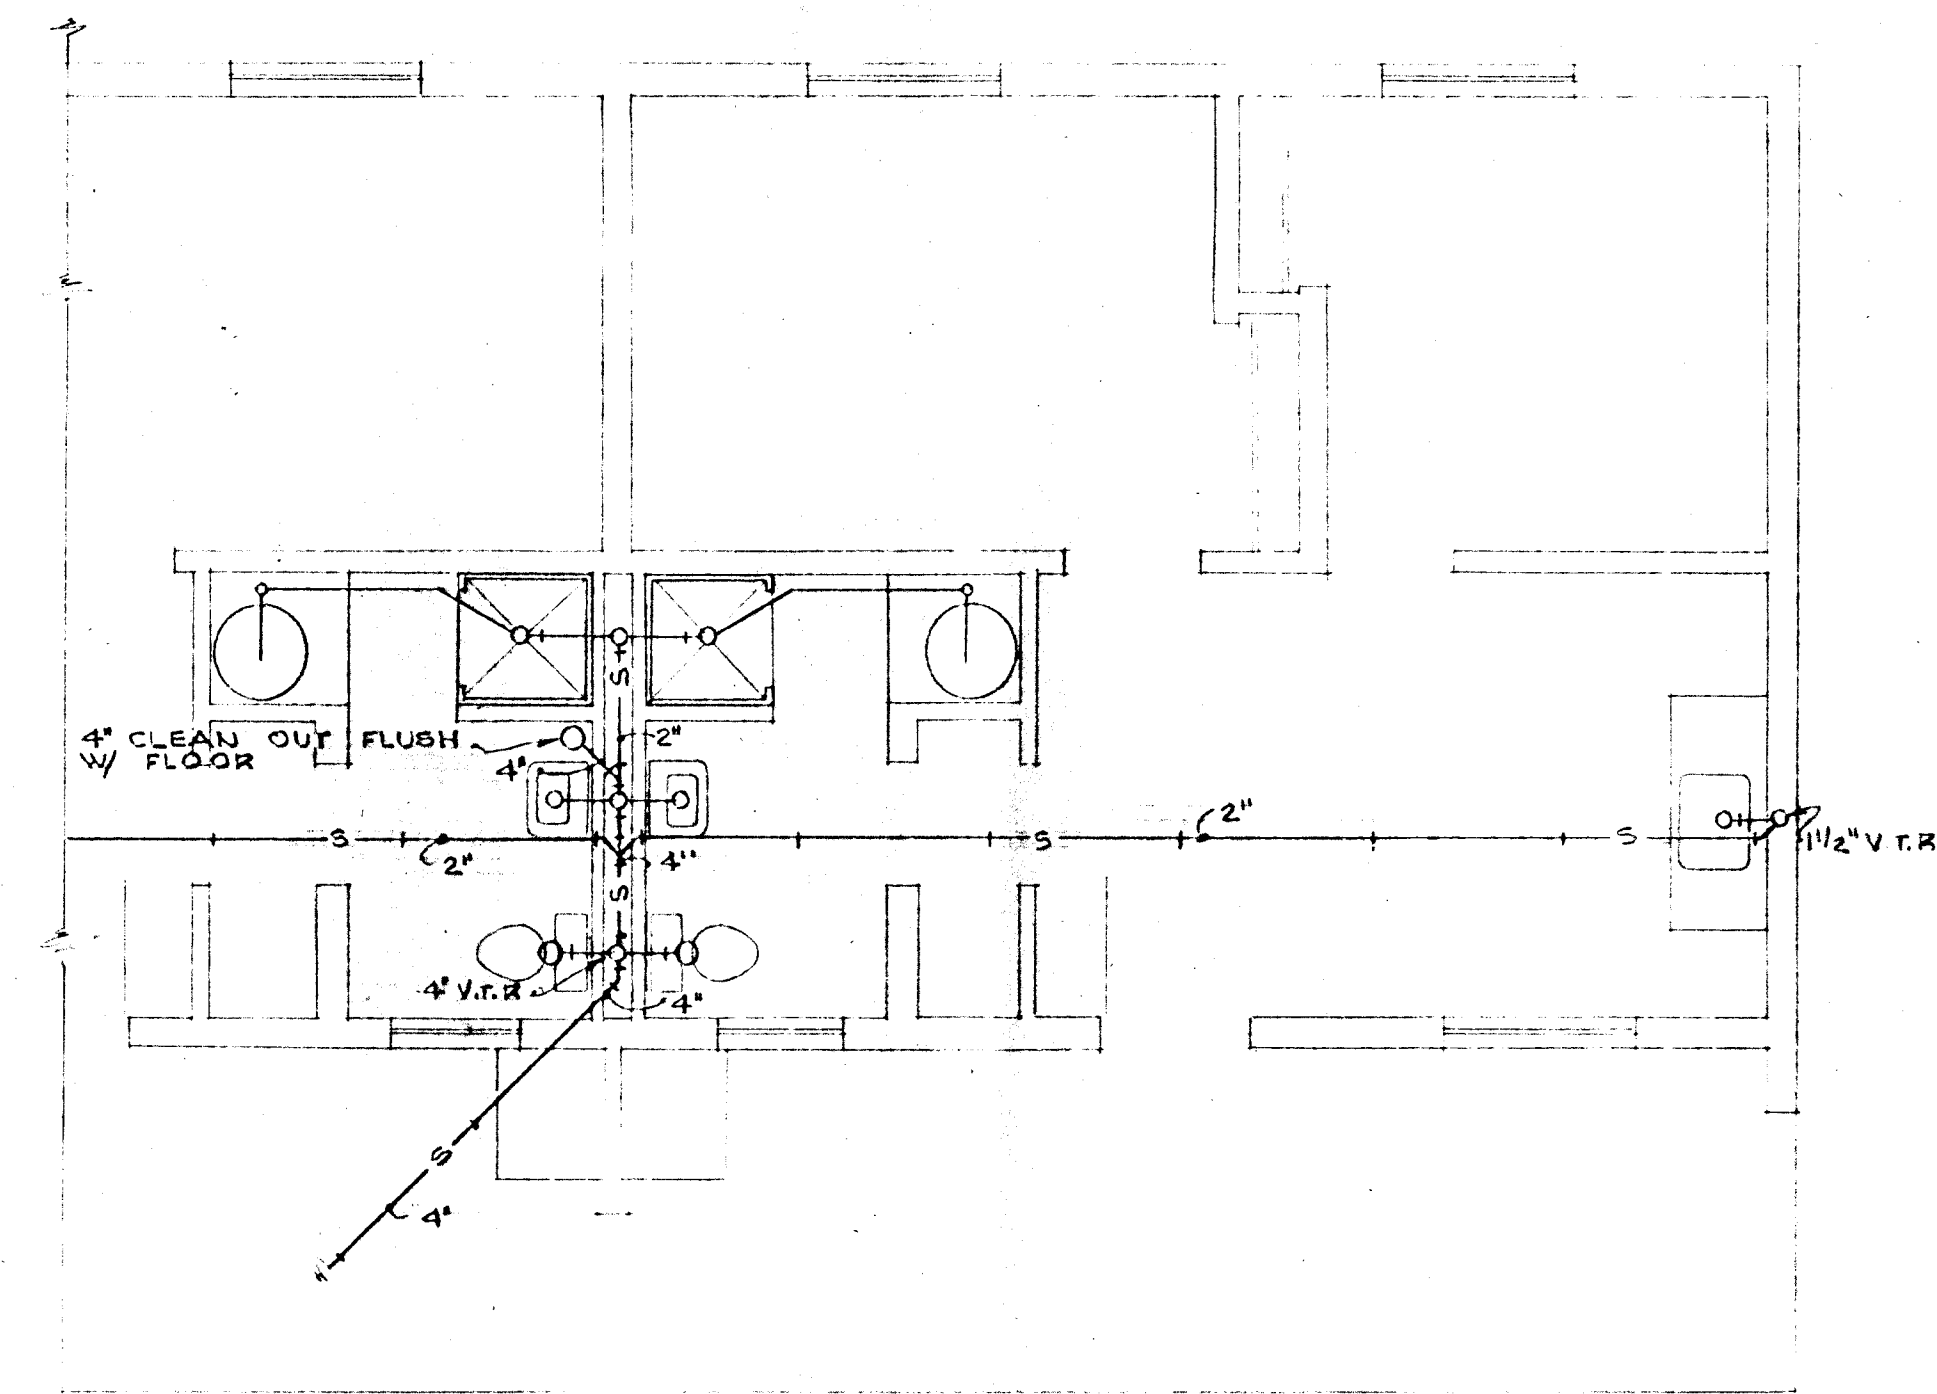


PLUMBING WASTE LAYOUT
TYPICAL @ ROW HOUSES NO. 6, 7, 8, 9, & 10 - SEE SHEET NO. 2
SCALE 1/4" = 2'-0"

THOMPSON & KOLBO Architects
A.I.A.
7071 FAIRVIEW AVENUE
717 ROOSEVELT AVENUE
BOISE, IDAHO
NAPPA, IDAHO

for
FARM LABOR CAMP
CALDWELL HOUSING AUTHORITY
IDAHO
CANYON COUNTY,



T	
K	
DRAWN BY: RS	DATE: 9-8-69
CHECKED: V	JOB NO.: 6916
SHEET NUMBER M-11 11 OF 13	

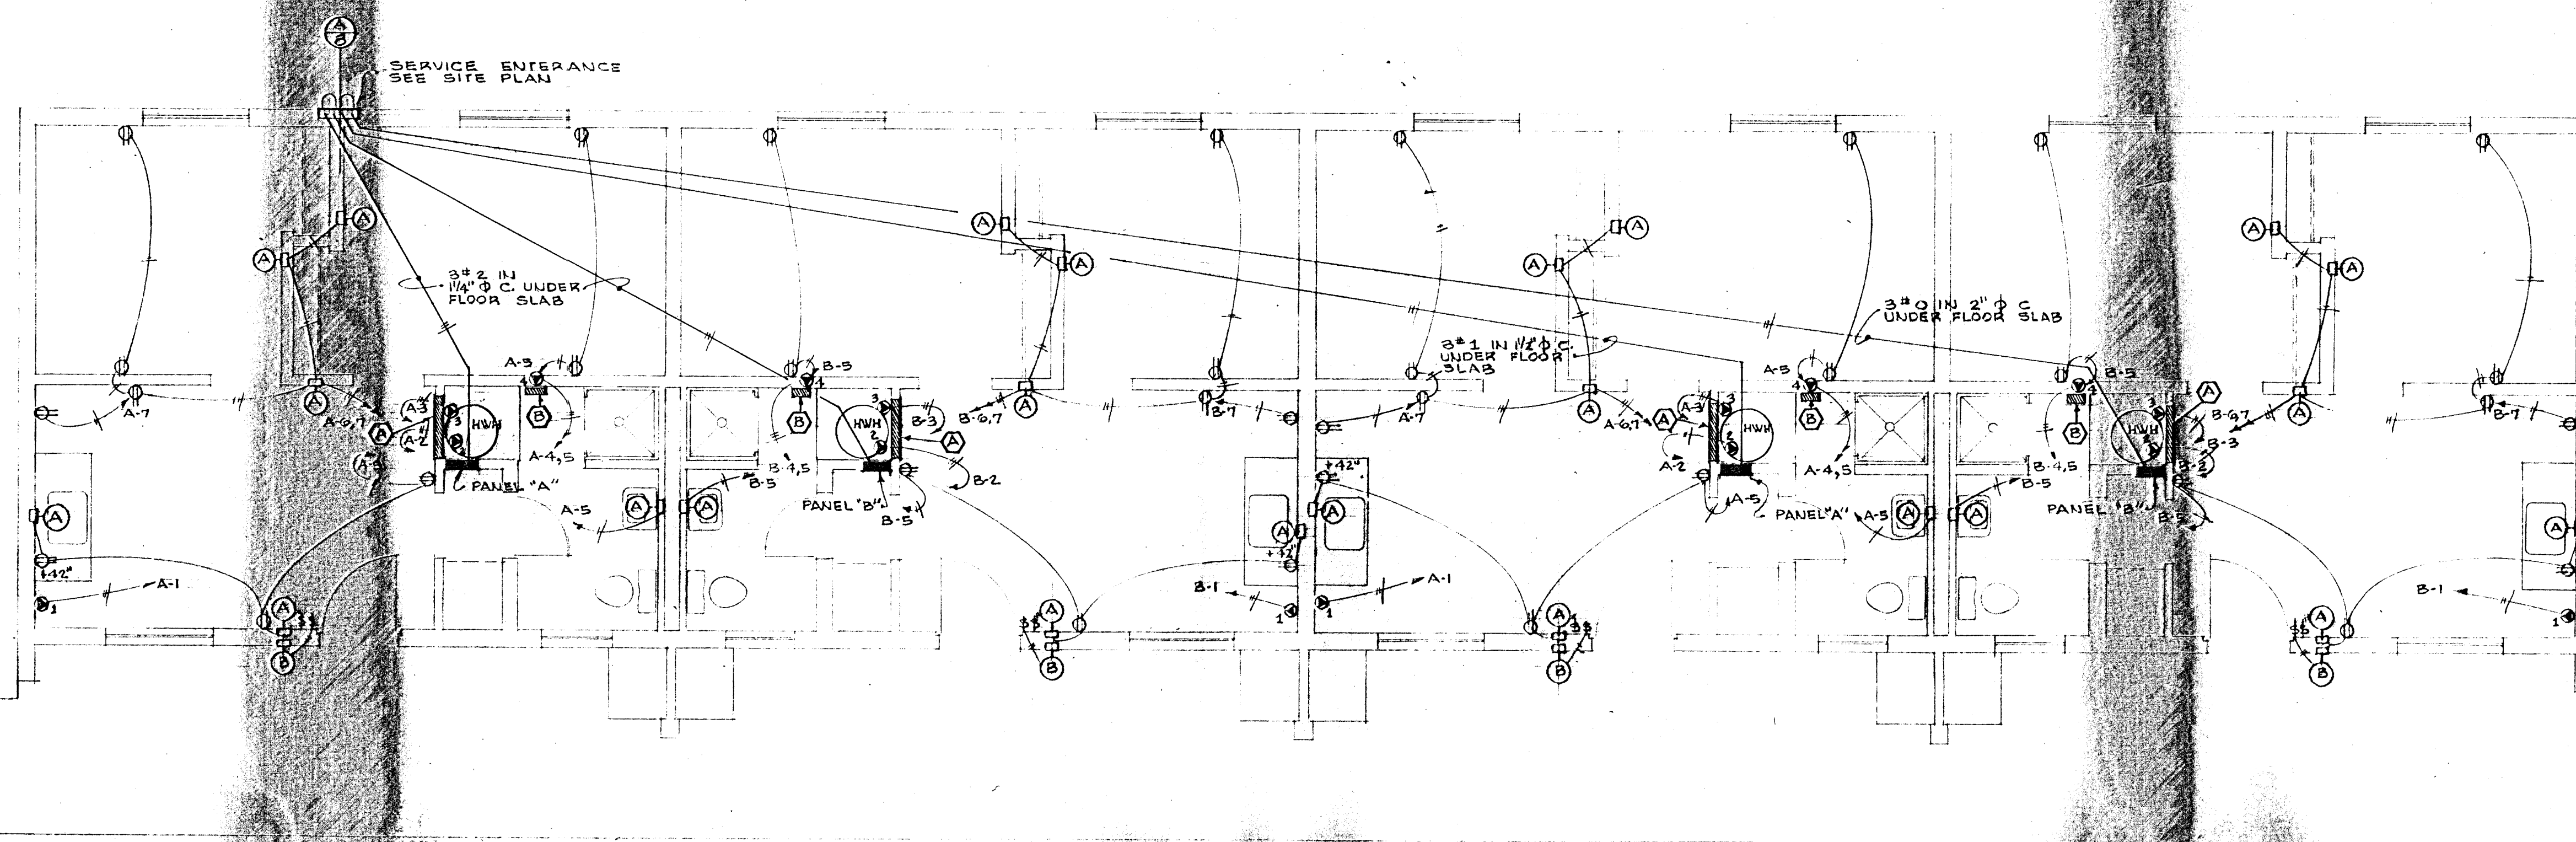


ELECTRICAL PLAN

PANEL A (B SEE NOTE) SCHEDULE

CIRCUIT NUMBER	NUMBER OF CIRCUITS	AMPS	TYPE	LOAD WATTS	CONDUCTOR SIZE	WIRE SIZE	TYPE
A-1	2	50	FUSETRON	8,100	33.5	33.5	RANGE
A-2	2	20	FUSETRON	1,500	10.8	10.8	H.W.
A-3	2	30	FUSETRON	6,000	25.0	25.0	ELECTRIC HEAT
A-4	1	20	FUSTAT	1,250	10.5		ELECTRIC HEAT
A-5	1	20	FUSTAT	1,380	11.5		LIGHTING & CONVENIENCE OUTLETS
A-6	1	20	FUSTAT	1,380	11.5		LIGHTING & CONVENIENCE OUTLETS
A-7	1	20	FUSTAT	200	2.3		REF. OUTLET
A-8	1		BLANK				BLANK SPACE W/ FILLER
				22,910	39.0	32.1	TOTAL

NOTE: ELECTRICAL PANEL "B" SAME AS PANEL "A" EXCEPT CIRCUITS NO. 3 & 4 CONNECTED TO Φ B
CIRCUITS NO. 4 & 5 CONNECTED TO Φ A

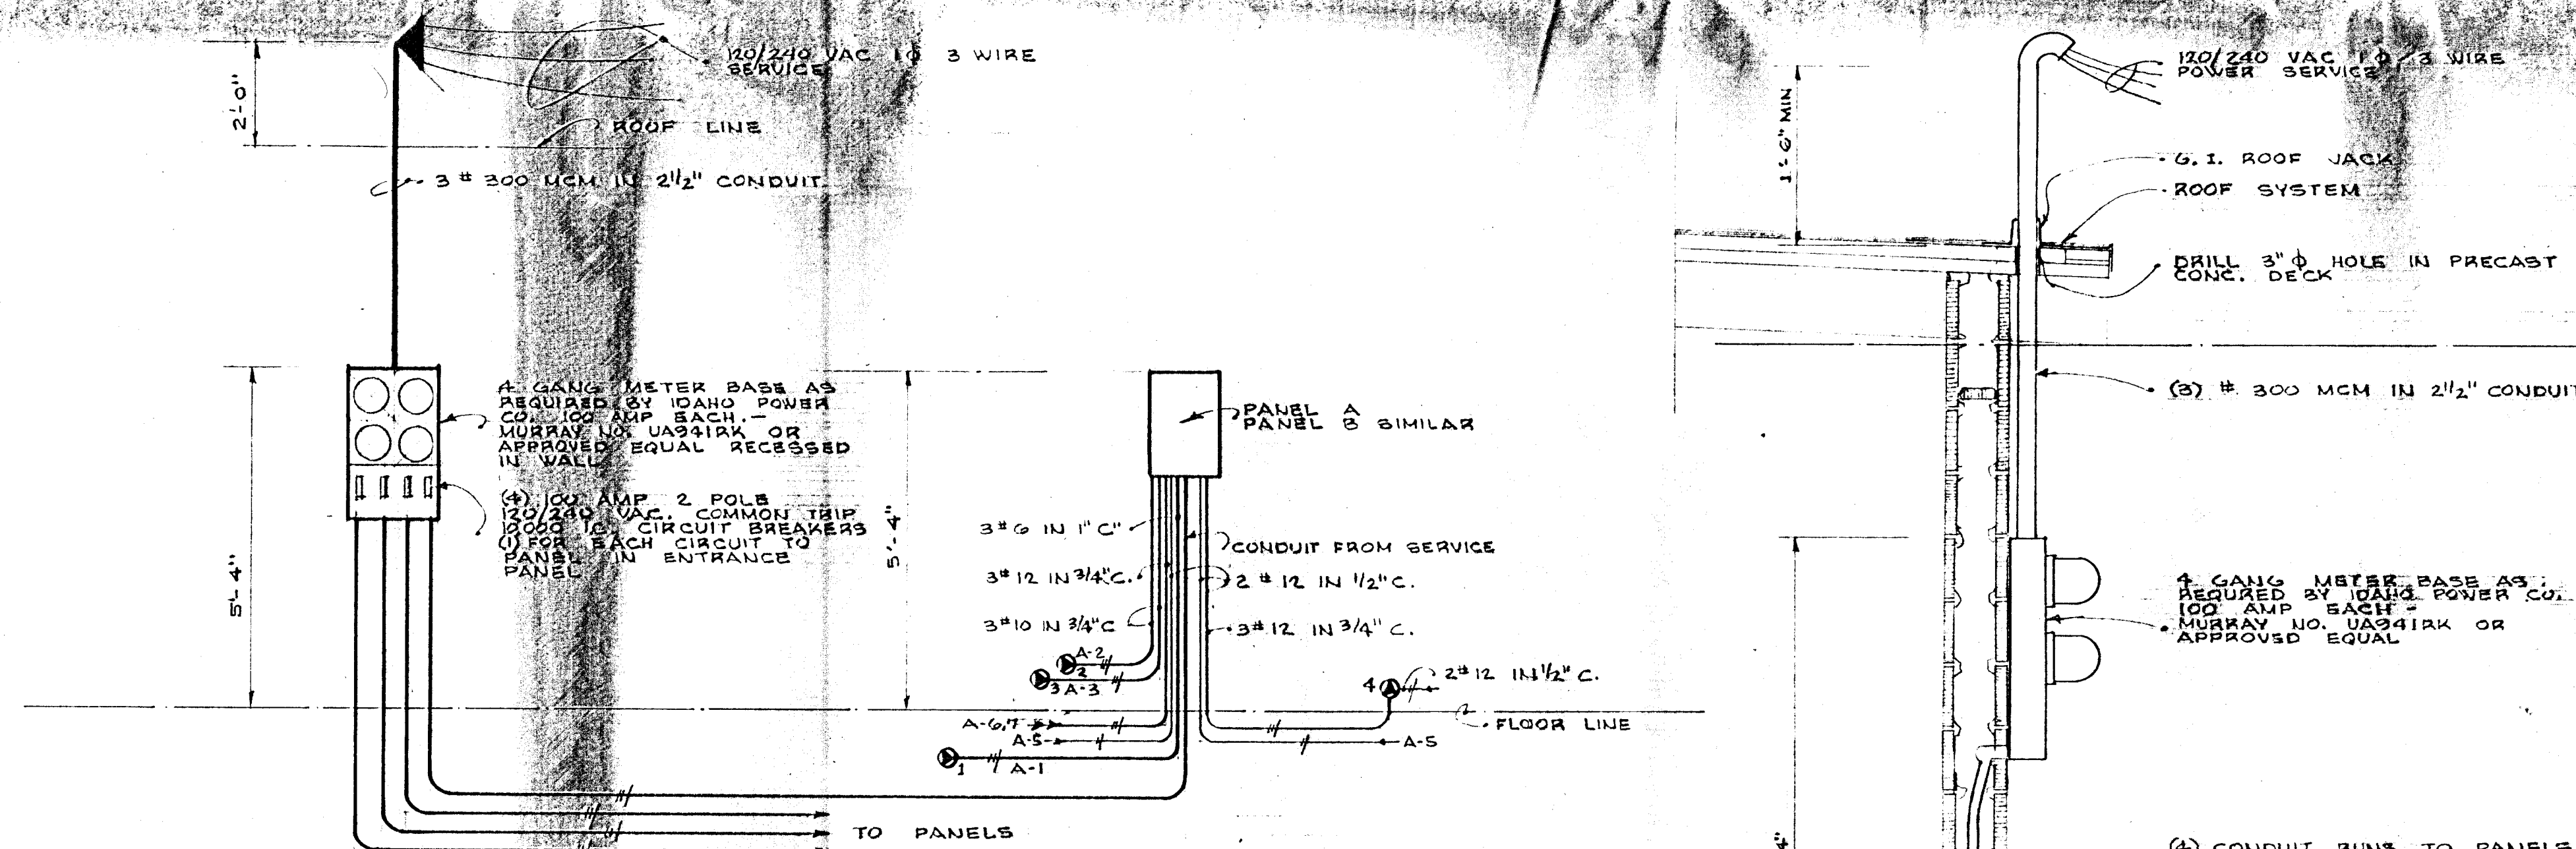

SYMBOLS

- Ⓐ PORCELAIN LAMP HOLDER W/ GROUNDING CONVENIENCE OUTLET & PULL CHAIN MOUNT ON OUTLET BOX IN BLOCK 6'-8" ABOVE FLOOR
- Ⓢ GROUNDING CONVENIENCE OUTLET IN OUTLET BOX IN BLOCK WALL 12" ABOVE FLOOR EQUALS OF BRYANT, P & S, OR HUBBEL ARE ACCEPTABLE
- Ⓢ RANGE OUTLET WIRE OUT OF J-BOX
- Ⓢ HOT WATER HEATER OUTLET WIRE OUT OF J-BOX
- Ⓢ ELECTRIC HEATER OUTLET WIRE OUT OF J-BOX
- Ⓢ ELECTRIC HEATER OUTLET WIRE OUT OF J-BOX
- Ⓐ ELECTRIC HEATER 6,000 W WALL-INSERT HEATER OR APPROVED EQUAL
- Ⓑ ELECTRIC HEATER 1,250 W WALL-INSERT HEATER OR APPROVED EQUAL

SYMBOLS


- Ⓑ WEATHERPROOF LIGHT FIXTURE W/ 100 W LAMP PRESOLITE NO. 108-2 BRUSHED ALUMINUM FINISH & W/ WG-6 GUARD INSTALL IN WEATHERPROOF BOX W/ WEATHERPROOF KIT MOUNT ON OUTLET BOX IN BLOCK 7'-8" ABOVE FLOOR LINE
- Ⓢ SINGLE POLE SWITCH IN OUTLET BOX IN BLOCK WALL 54" ABOVE FLOOR EQUALS OF BRYANT, P & S, OR HUBBEL ACCEPTABLE

SERVICE ENTRANCE DETAIL Ⓐ


SCALE 3/4" = 1'-0"

NOTE


ALL CONTRACTORS AND/OR THEIR SUBCONTRACTORS SHALL BE RESPONSIBLE TO VISIT THE SITE AND MAKE THEMSELVES FAMILIAR W/ THE WORK TO BE PERFORMED UNDER THIS CONTRACT

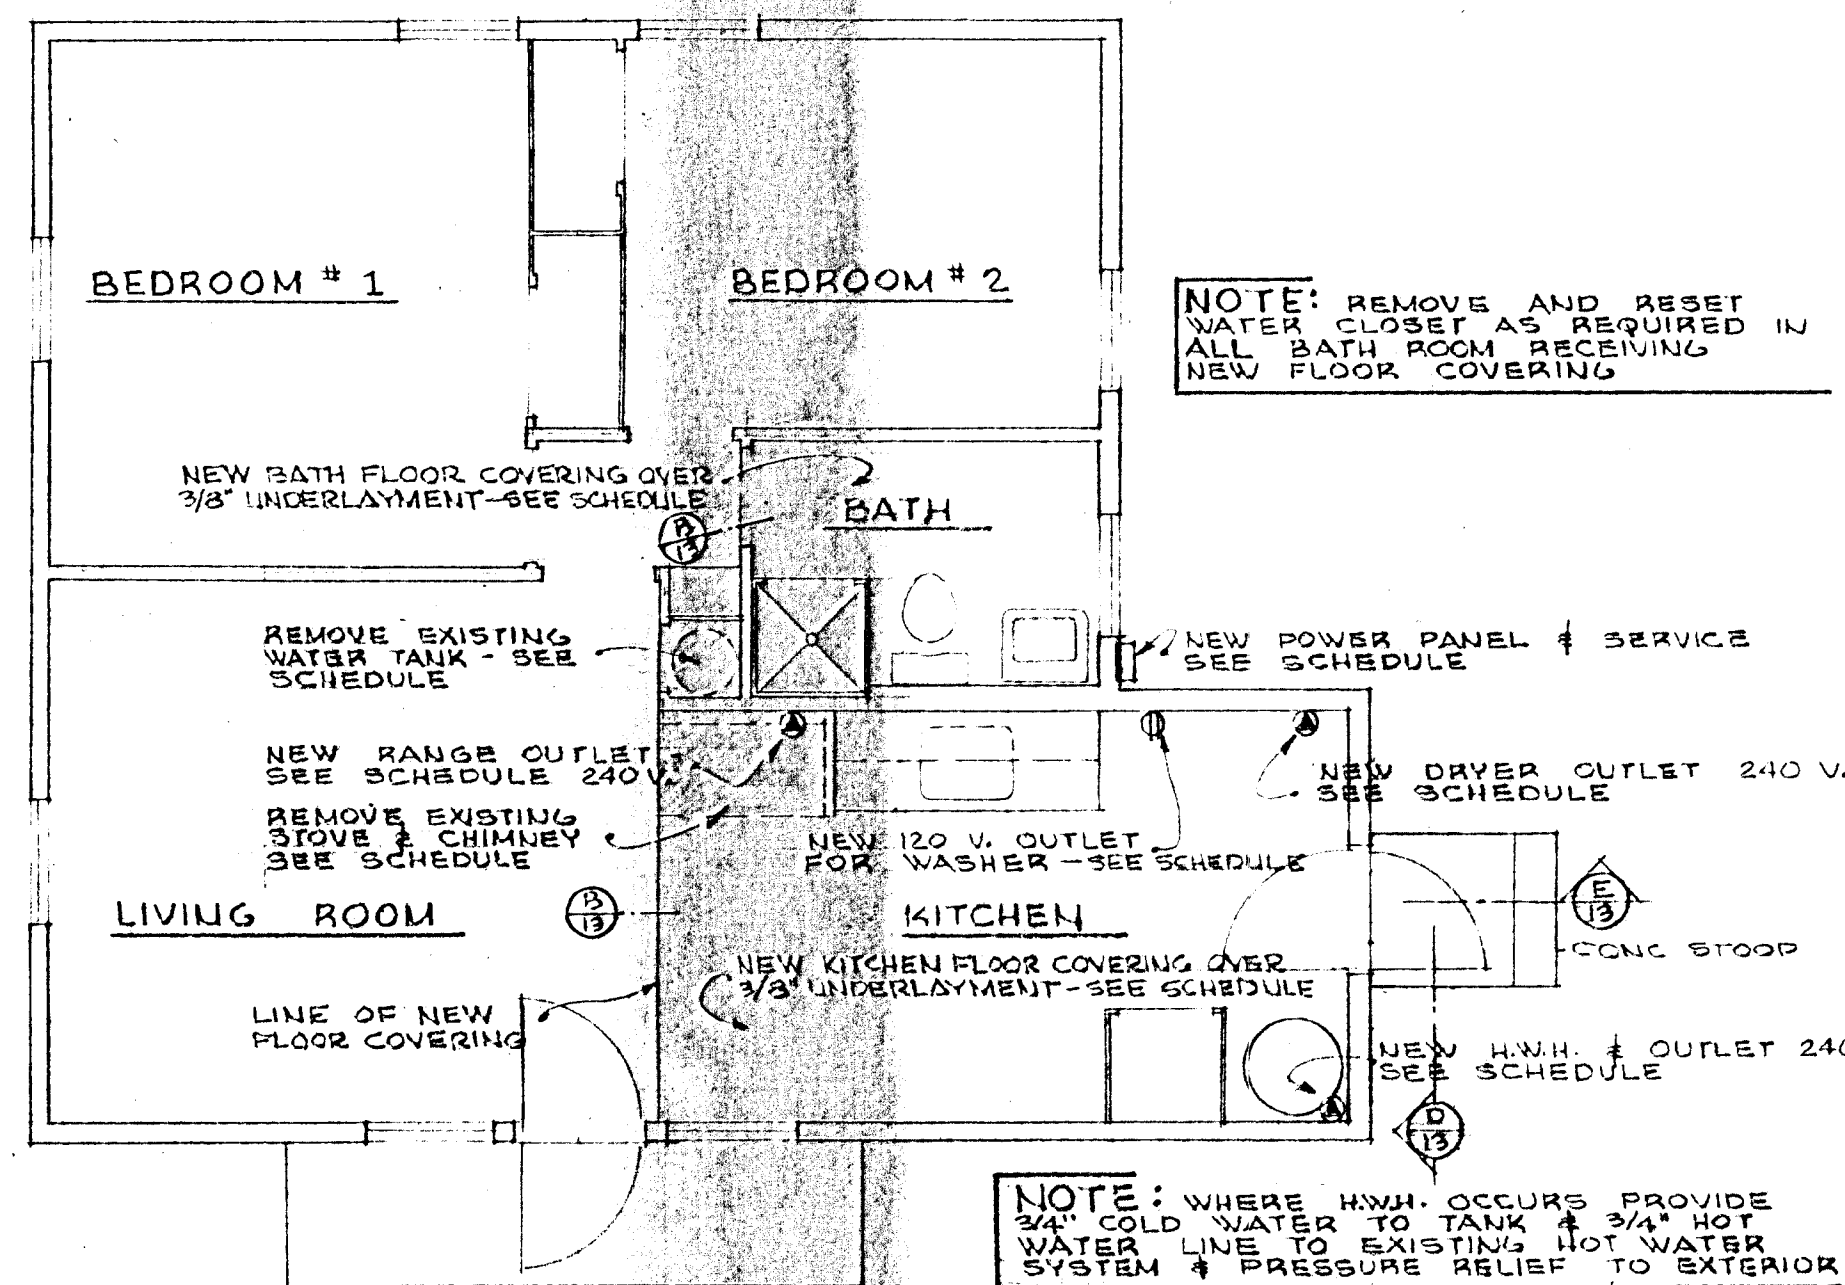


TYPICAL FLOOR PLAN
SCALE 1/4" = 1'-0"

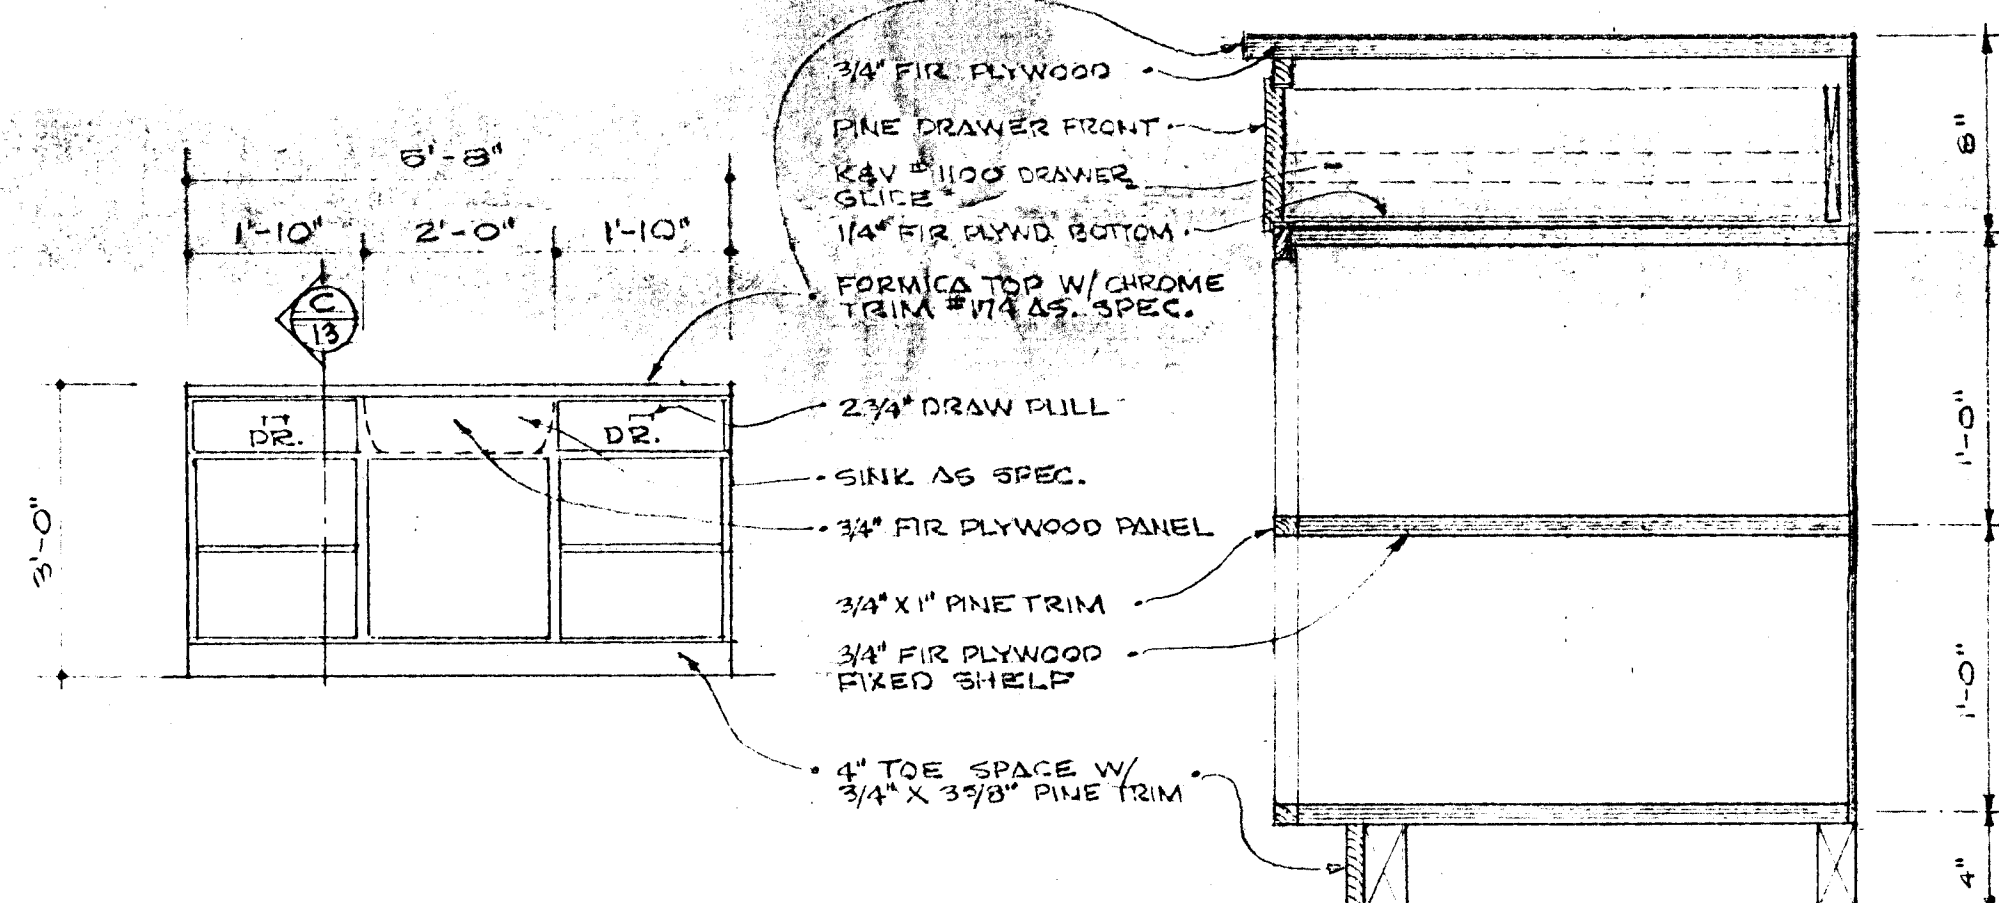

(1) REQUIRED @ UNIT NO. 24 ONLY
CABINET DETAIL A SECTION C
SCALE 1/2" = 1'-0"

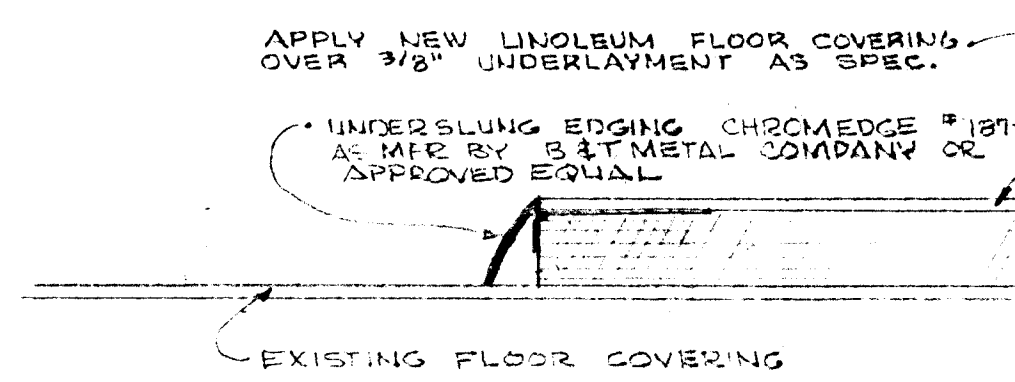


(SEE SCHEDULE FOR LOCATION)
FLOOR DETAIL B
FULL SCALE

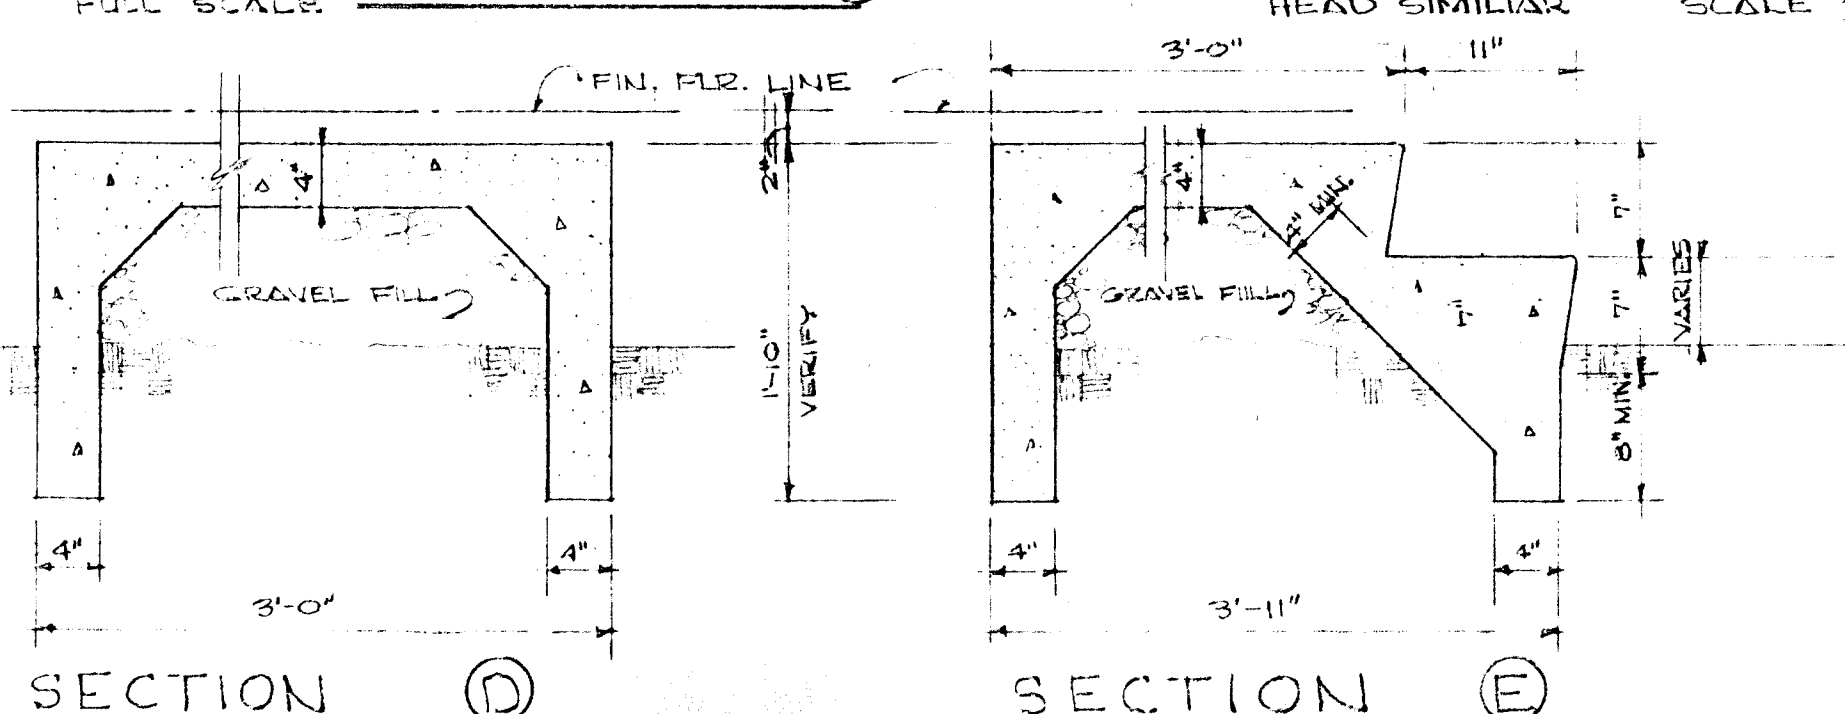

REMODELING SCHEDULE INDIVIDUAL HOUSING UNITS

SINGLE DWELLING UNIT NUMBER	FLOORS	FRONT DOOR	REAR DOOR	MISC.	PAINTING	ELECTRICAL	REMARKS
NOTE SEE SHEET #1 FOR LOCATION OF HOUSING UNITS							
NO. 1							
NO. 2							
NO. 3							
NO. 4							
NO. 5							
NO. 6							
NO. 7							
NO. 8							
NO. 9							
NO. 10							
NO. 11							
NO. 12							
NO. 13							
NO. 14							
NO. 15							
NO. 16							
NO. 17							
NO. 18							
NO. 19							
NO. 20							
NO. 21							
NO. 22							
NO. 23							
NO. 24							
NO. 25							
NO. 26							
NO. 27							
NO. 28							
NO. 29							
NO. 30							
NO. 31							
NO. 32							
NO. 33							
NO. 34							
NO. 35							
NO. 36							
NO. 37							
NO. 38							
NO. 39							
NO. 40							
NO. 41							
NO. 42							
NO. 43							
NO. 44							
NO. 45							
NO. 46							
NO. 47							
NO. 0							

DOOR SCHEDULE
SCALE 1/4" = 1'-0"

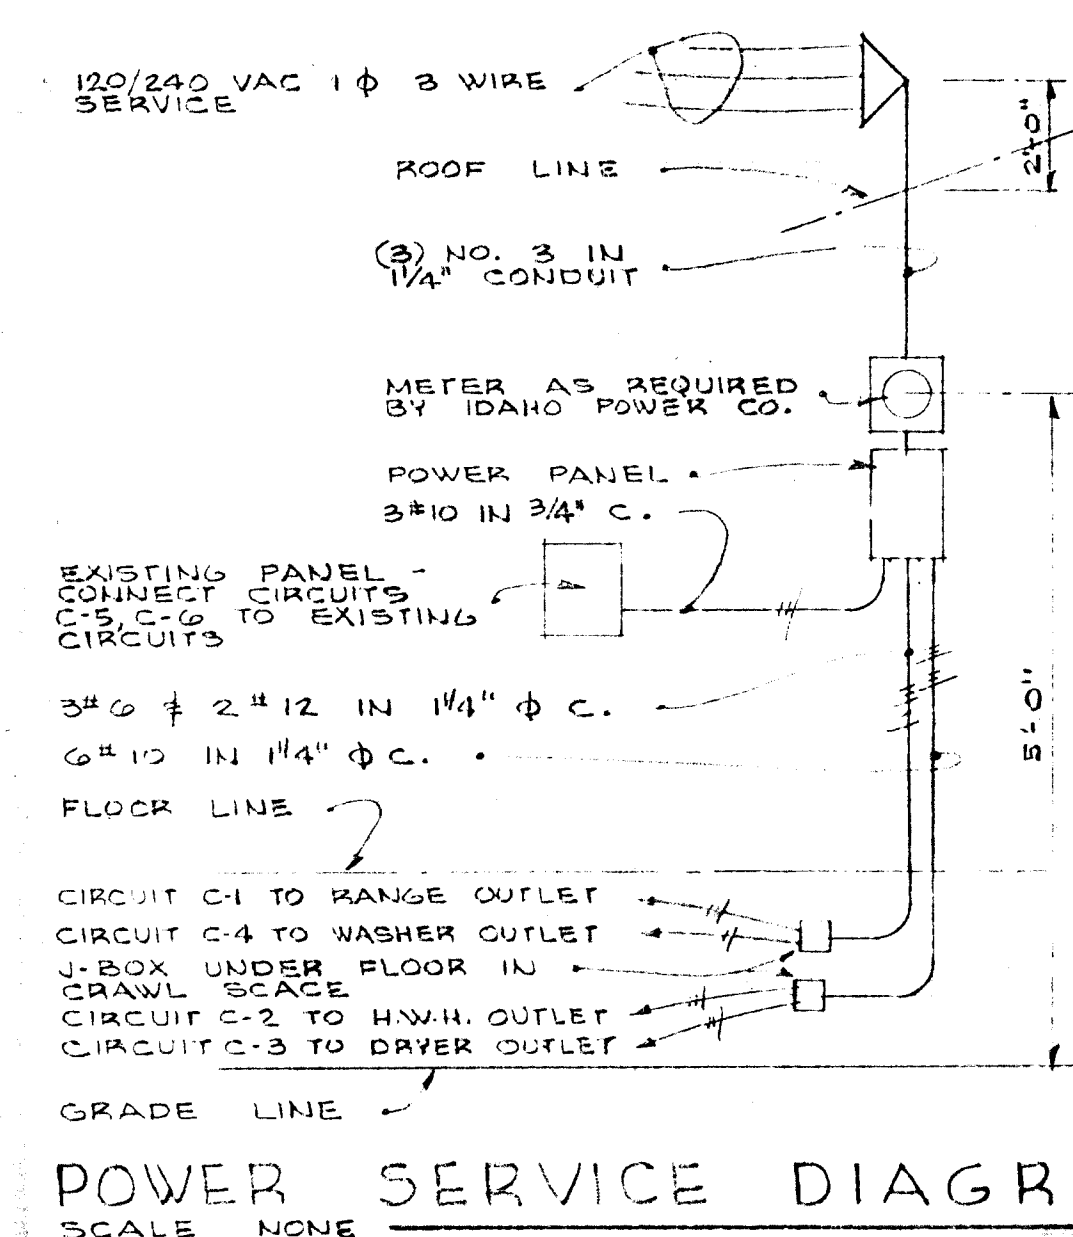


POWER SERVICE DIAGRAM
SCALE NONE

PANEL "C" SCHEDULE									
CIRCUIT NUMBER	CIRCUIT PROTECTION		LOAD WATTS	CONDUIT LOAD AMPS		WIRE SIZE	TYPE: FUSIBLE LOAD CENTER		
	NUMBER	AMPS		Ø	Ø		VOLTS: 120/240 VAC 1 Ø 3 WIRE	MAIN: 100 A. MAIN DISCONNECT	WIRE:
C-1	2	30	FUSETRON	10,000	41.8	41.8	#10	RANGE OUTLET	
C-2	2	30	FUSETRON	4,500	18.3	18.3	#10	H.W.H. OUTLET	
C-3	2	30	FUSETRON	5,000	20.9	20.9	#10	DRYER OUTLET	
C-4	1	20	FUSTAT	700	5.3		#12	WASHER OUTLET	
C-5	1	20	FUSTAT	150		6.3	#12	CONNECT TO EXISTING CIRCUITS	
C-6	1	20	FUSTAT	150		6.3	#12	CONNECT TO EXISTING CIRCUITS	
				21,700	93.7	93.8		TOTAL	

NOTE
SEE REMODELING SCHEDULE THIS SHEET FOR HOUSING UNITS TO RECEIVE NEW ELEC. WORK

THOMPSON & KOLBO Architects
A.I.A.
7071 FAIRVIEW AVENUE
717 ROOSEVELT AVENUE
BOISE, IDAHO
Nampa, IDAHO

FARM LABOR CAMP
CALDWELL HOUSING AUTHORITY
IDAHO
CANYON COUNTY.

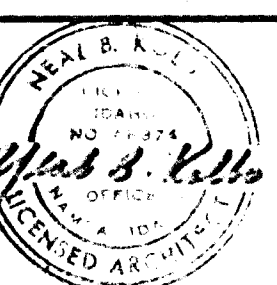


DRAWN BY: DATE: 9-8-89
RS WRS
CHECKED: 6918
SHEET NUMBER
R-13
13 OF 13


PANEL "D" SCHEDULE									
CIRCUIT NUMBER	CIRCUIT BREAKERS			LOAD WATTS	CONN. LOAD		TYPE: MURRAY NLAB	VOLTS: 120/240 3 WIRE 1 φ	MAIN: 100 AMP. MAIN LUG
	AMPS	NUMBER	WIRE		A	V			
D-1	20	1	NLAB	1,200	10.0		WIRE: 3 #6		
D-2				1,200	10.0		FEDD: TOP		
D-3				1,400	11.8		CONDUIT: 1/4" φ		
D-4				1,400	11.8		MOUNTING: SURFACE		
D-5				1,400	11.8				
D-6				1,400	11.8				
D-7				1,400	11.8				
D-8				1,400	11.8				
D-9				1,400	11.8				
D-10				1,400	11.8				
D-11				300					UNIT HEATER
D-12									SPARE
									SPACE

NOTE 1
ALL CONTRACTORS AND/OR THEIR SUBCONTRACTORS SHALL BE RESPONSIBLE TO VISIT THE SITE AND MAKE THEMSELVES FAMILIAR WITH THE WORK TO BE PERFORMED UNDER THIS CONTRACT.


NOTE 2
PAINT ENTIRE CENTRAL UTILITY BUILDING EXTERIOR AS SPEC.

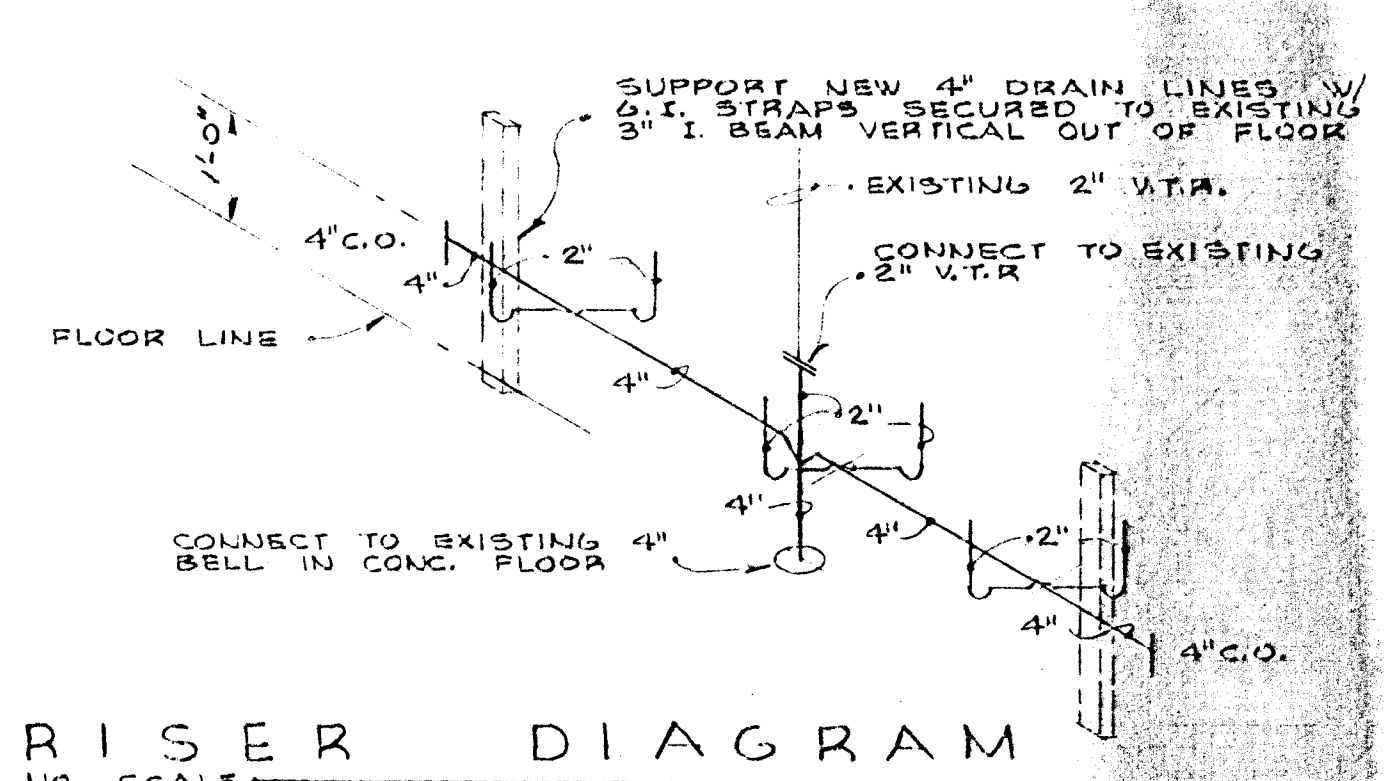


RISER DIAGRAM
NO. SCALE

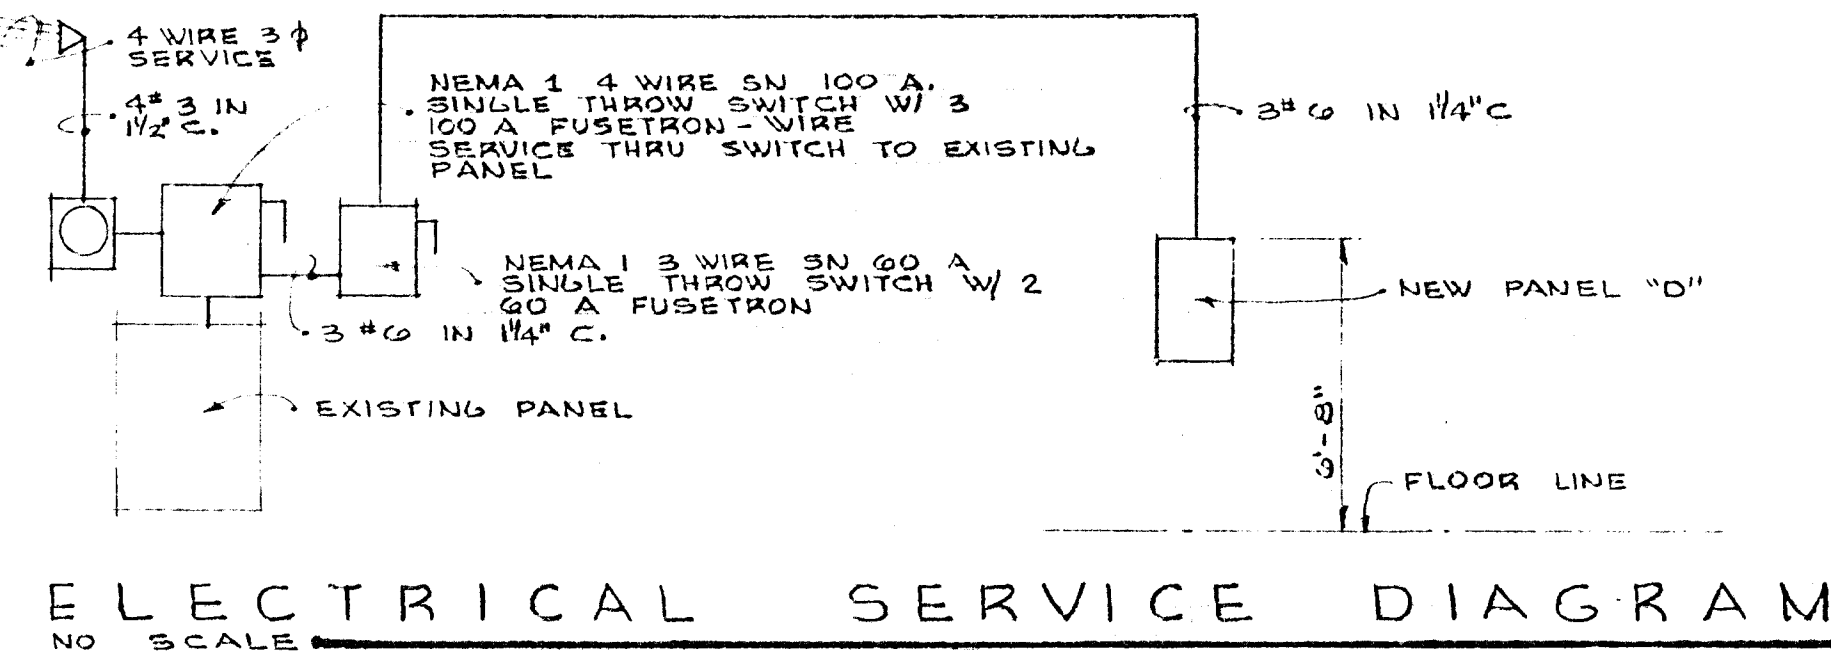


ELECTRICAL SERVICE DIAGRAM
NO. SCALE

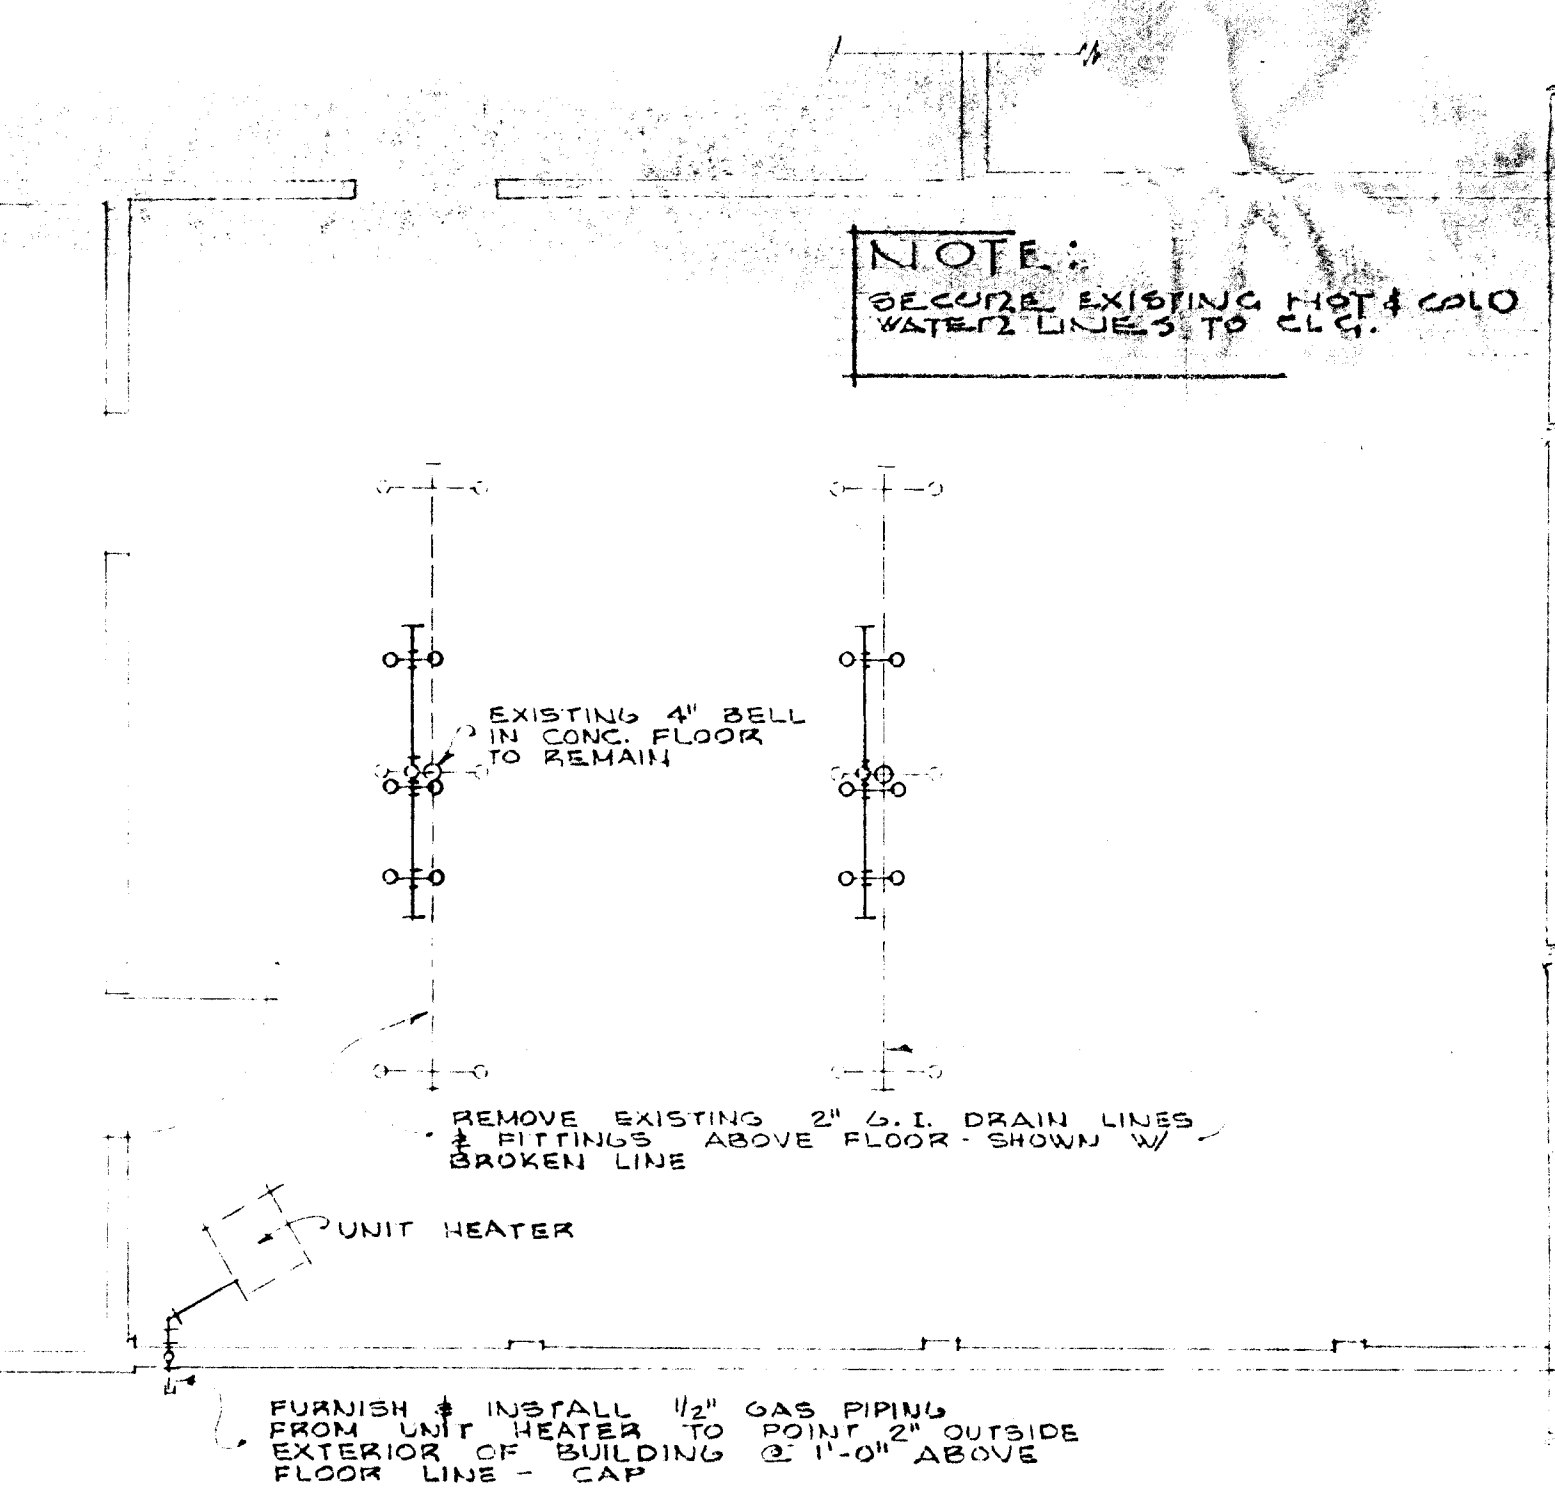

PLUMBING PLAN
SCALE 1/4" = 1'-0"

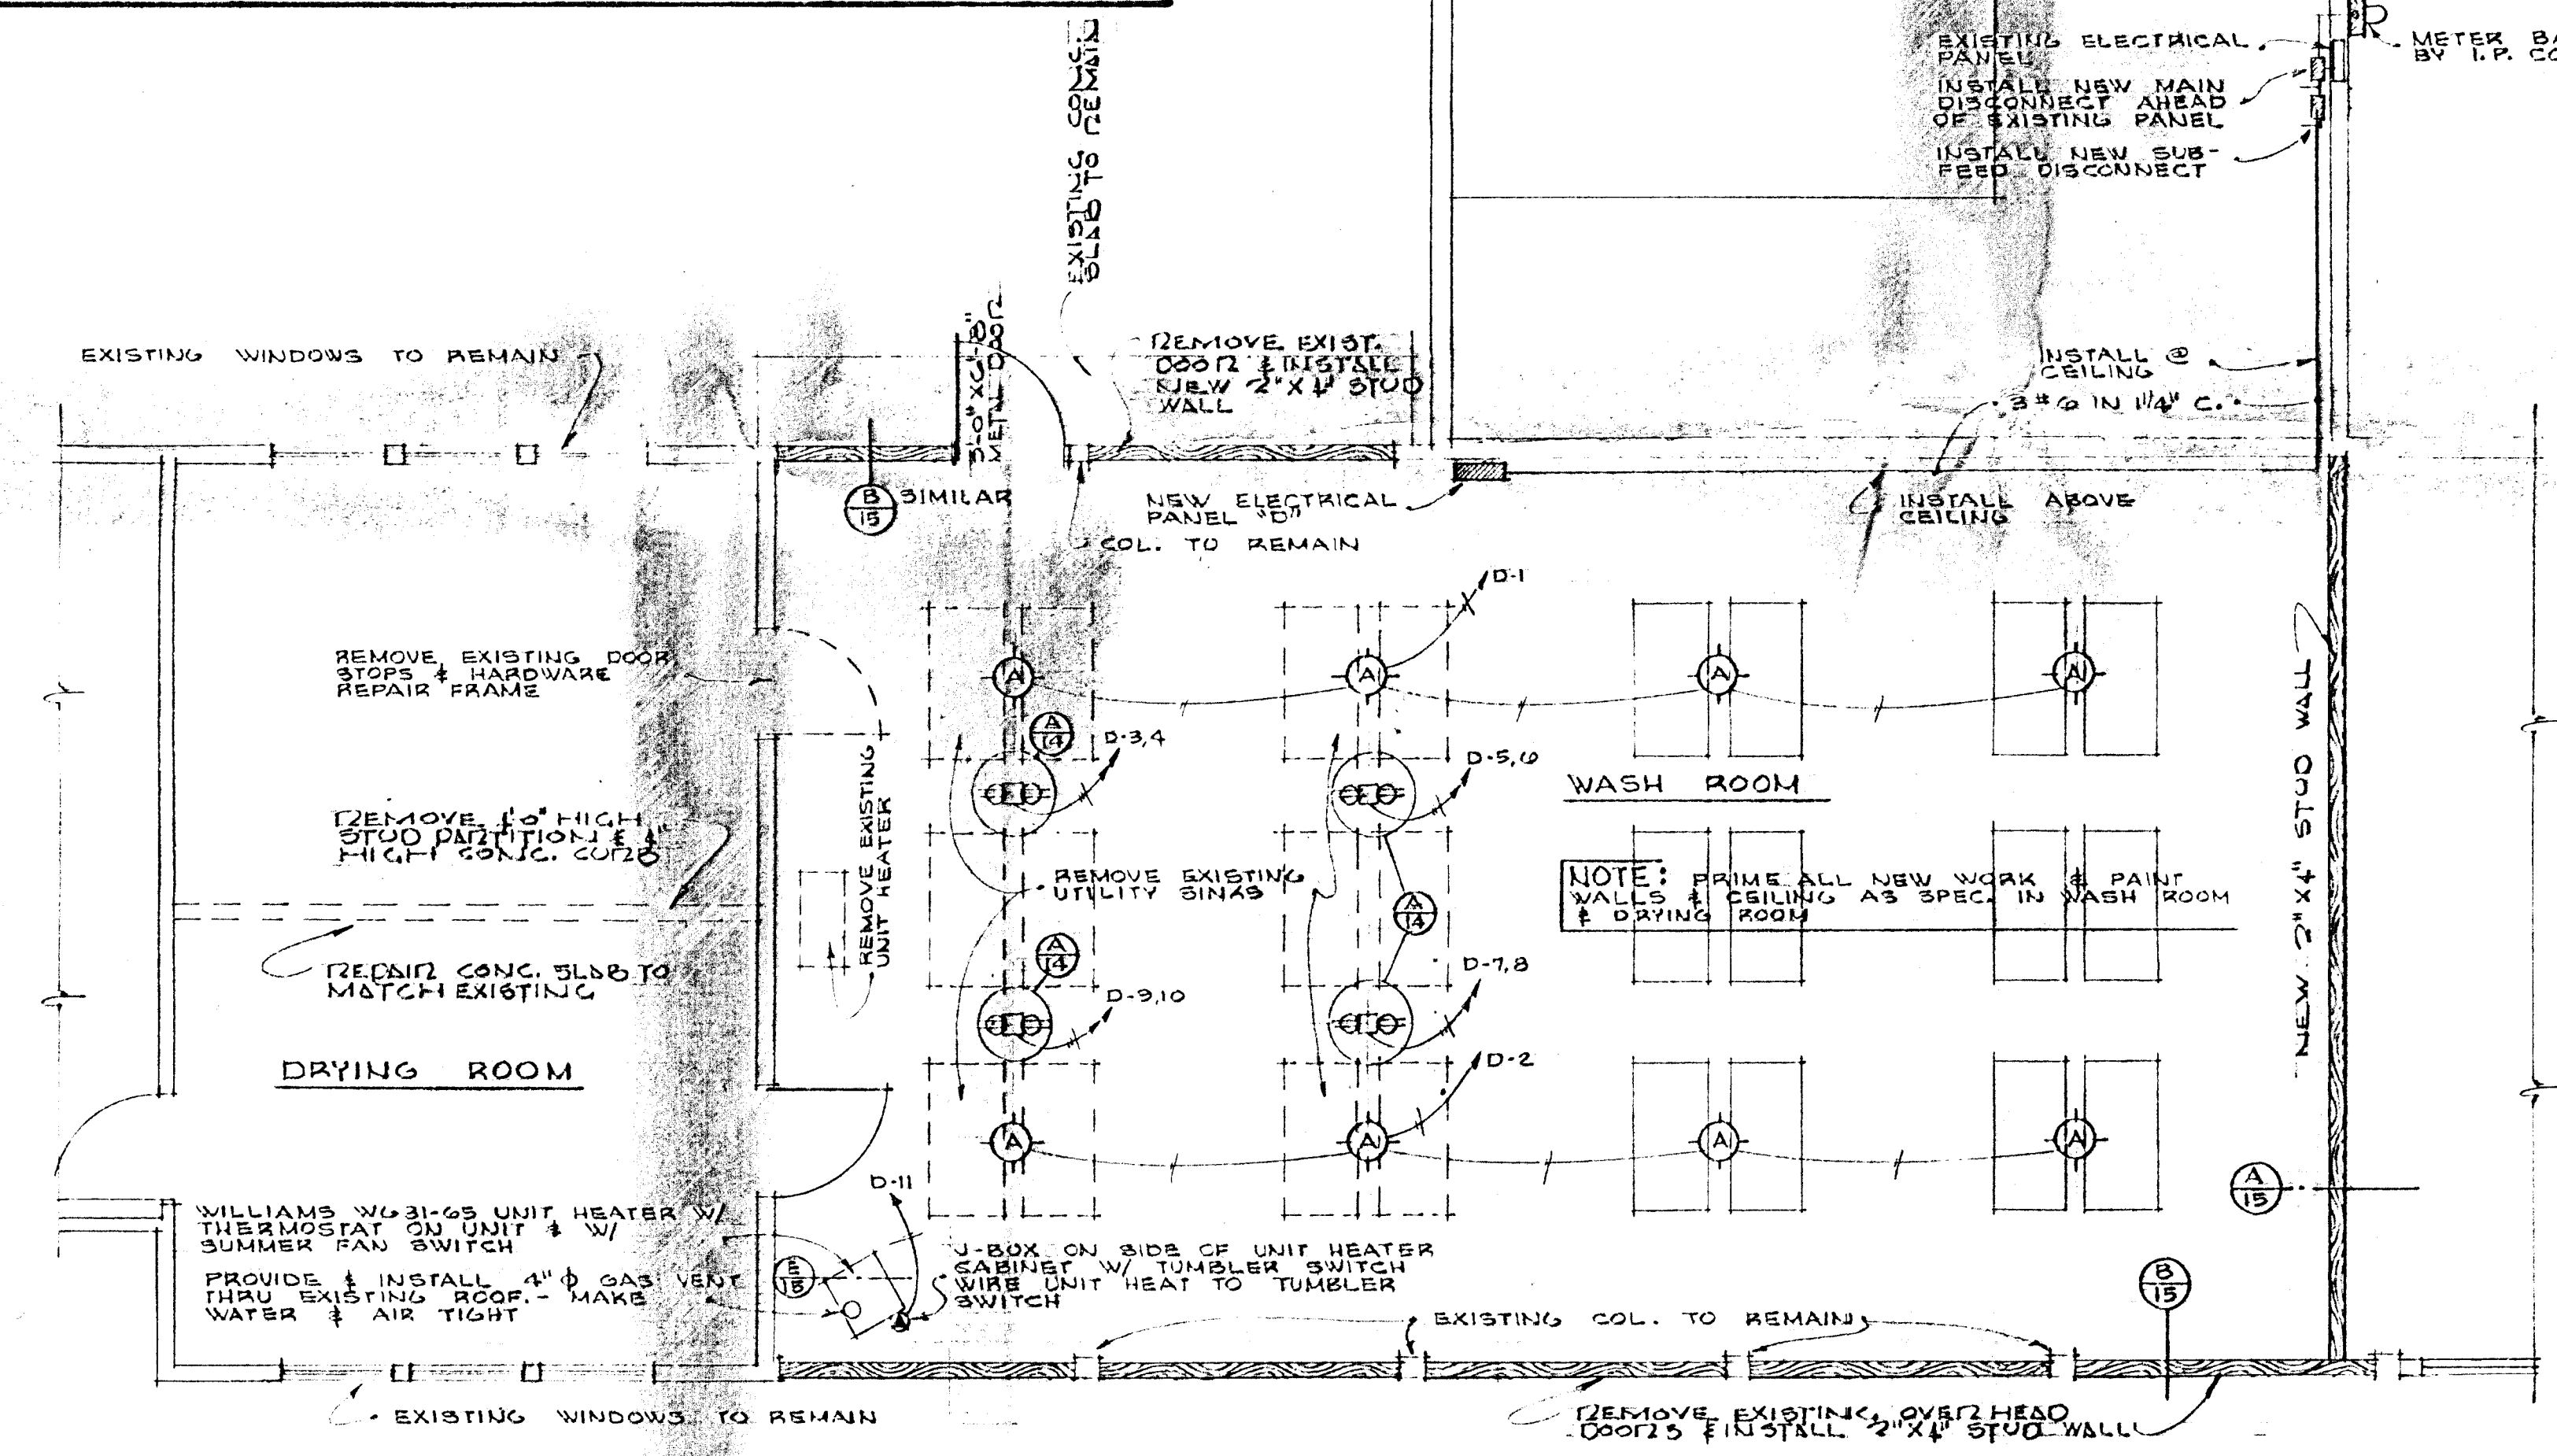

FLOOR PLAN WASHATERIA
SCALE 1/4" = 1'-0"

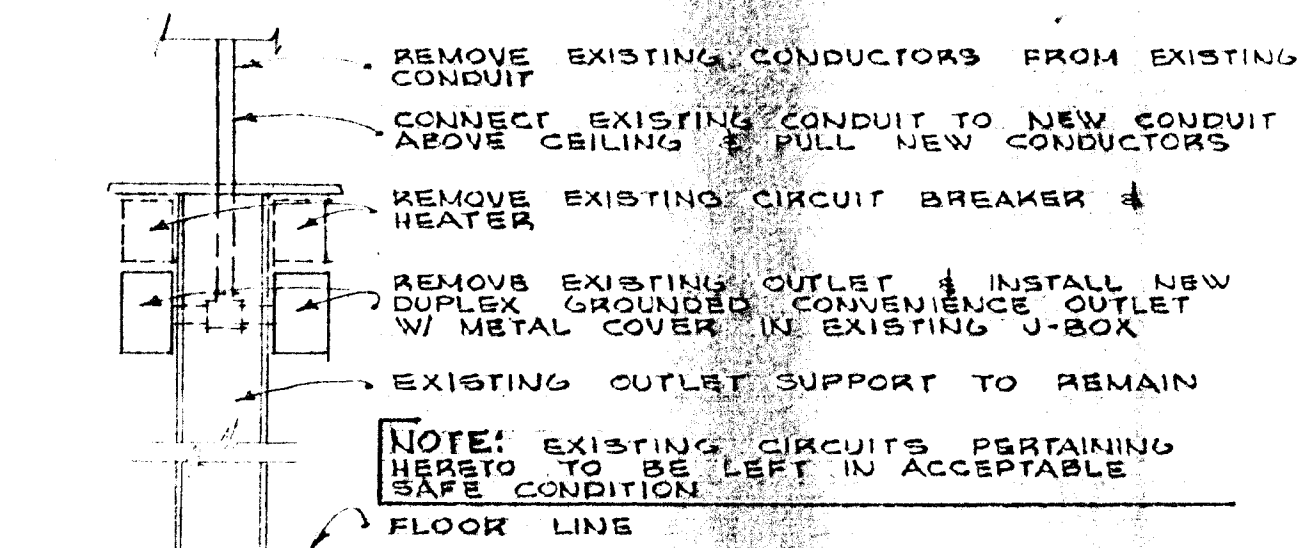

DETAIL A
NO. SCALE

ELECTRICAL NOTE

⊙ INDICATES NEW PORCELAIN LAMP HOLDER ON J-BOX W/ 300 W. INCAND. LAMP

ALL NEW CIRCUITS FROM PANEL "D" TO BE RUN IN 3/4" CONDUIT ABOVE NEW CEILING

NEW ELECTRICAL TO BE GROUNDED AS REQUIRED BY N.E.C.

THOMPSON & KOLBO Architects
A.I.A.
7071 FAIRVIEW AVENUE
717 ROOSEVELT AVENUE
BOISE, IDAHO
Nampa, IDAHO


for
FARM LABOR CAMP
CALDWELL HOUSING AUTHORITY
CANYON COUNTY, IDAHO

NEAL R. KOLBO
LICENSED ARCHITECT
IDAHO
NO. 1000
OFFICE
Nampa, IDAHO


T K

DRAWN BY: JCS: R.S. DATE: 3-8-69
CHECKED: JCS: R.S. NO. 1: 0310


SHEET NUMBER
R-14
14 OF 15

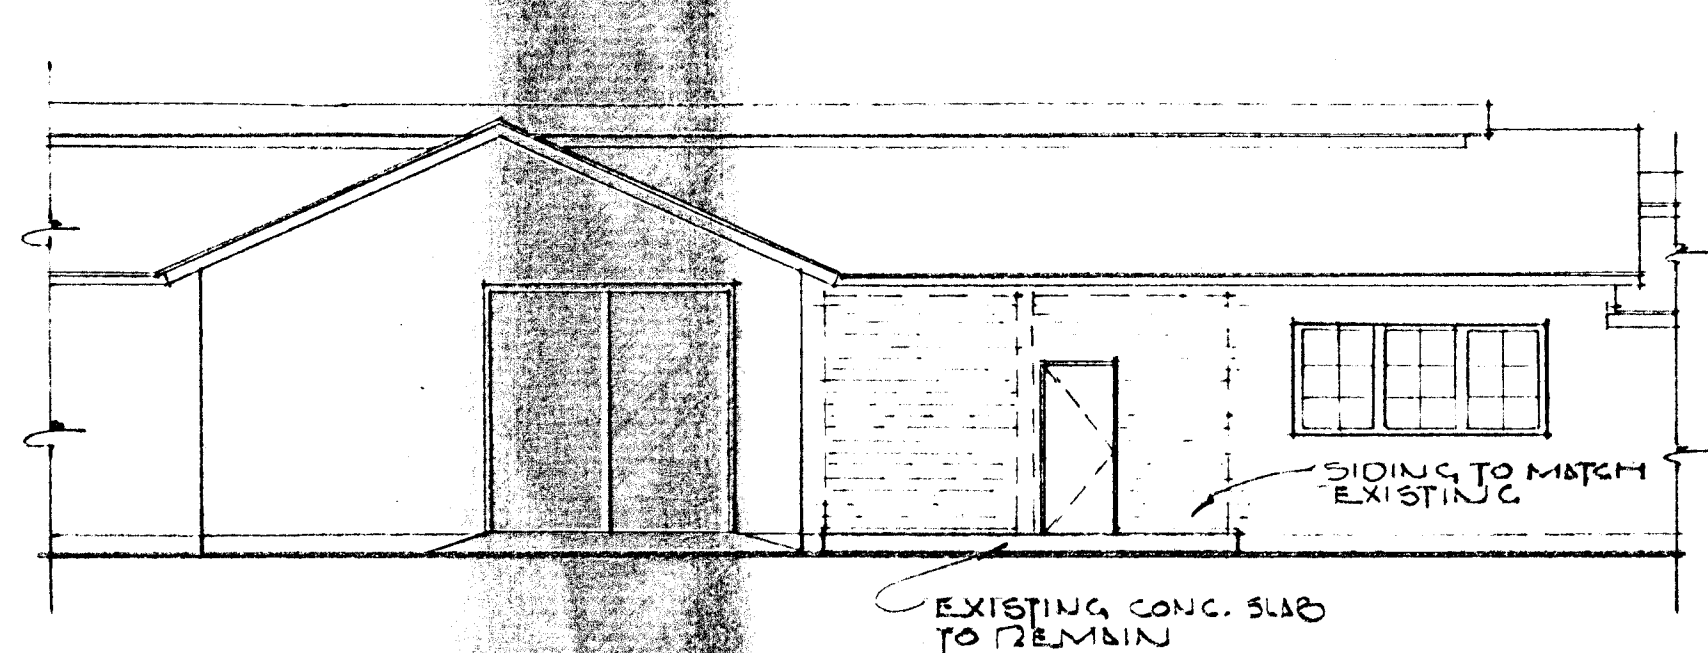


NORTH ELEVATION
1/8" = 1'-0"

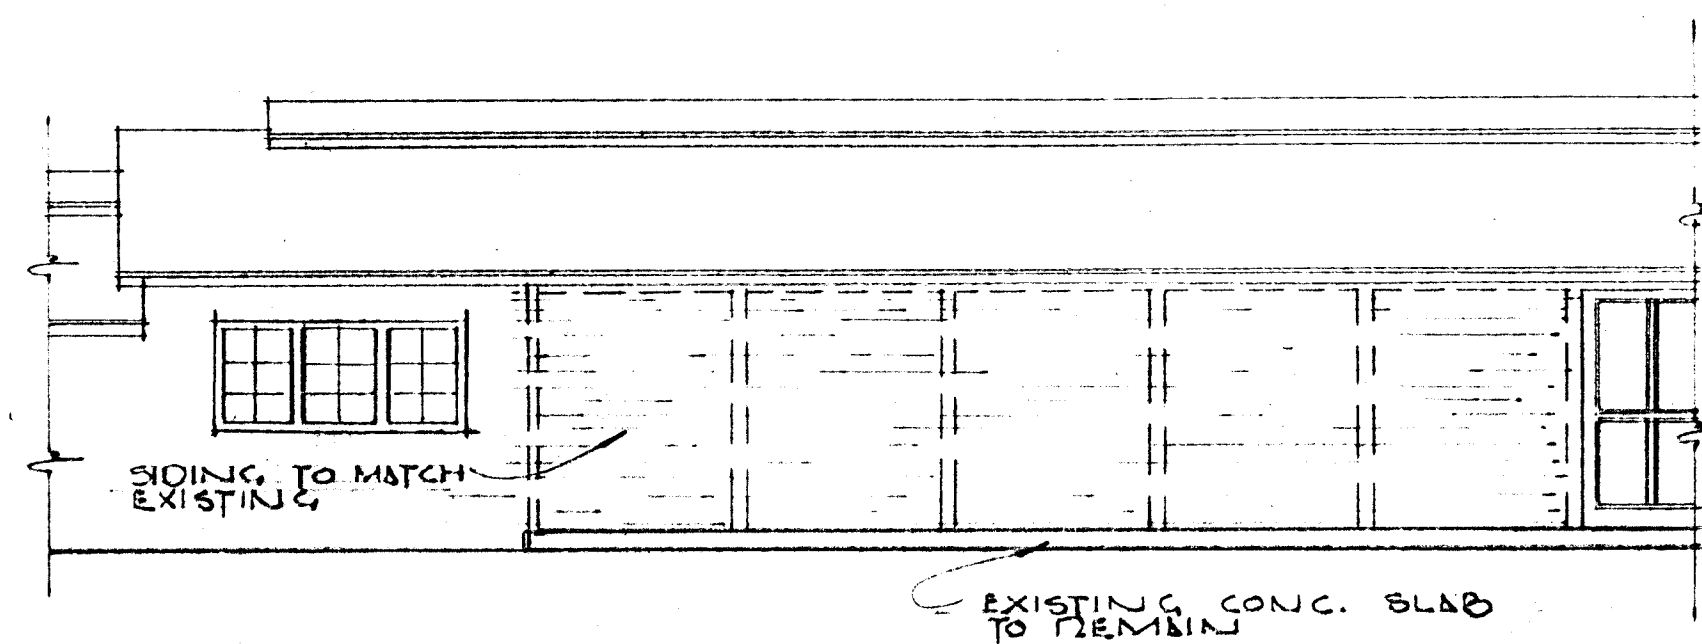


SOUTH ELEVATION
1/8" = 1'-0"

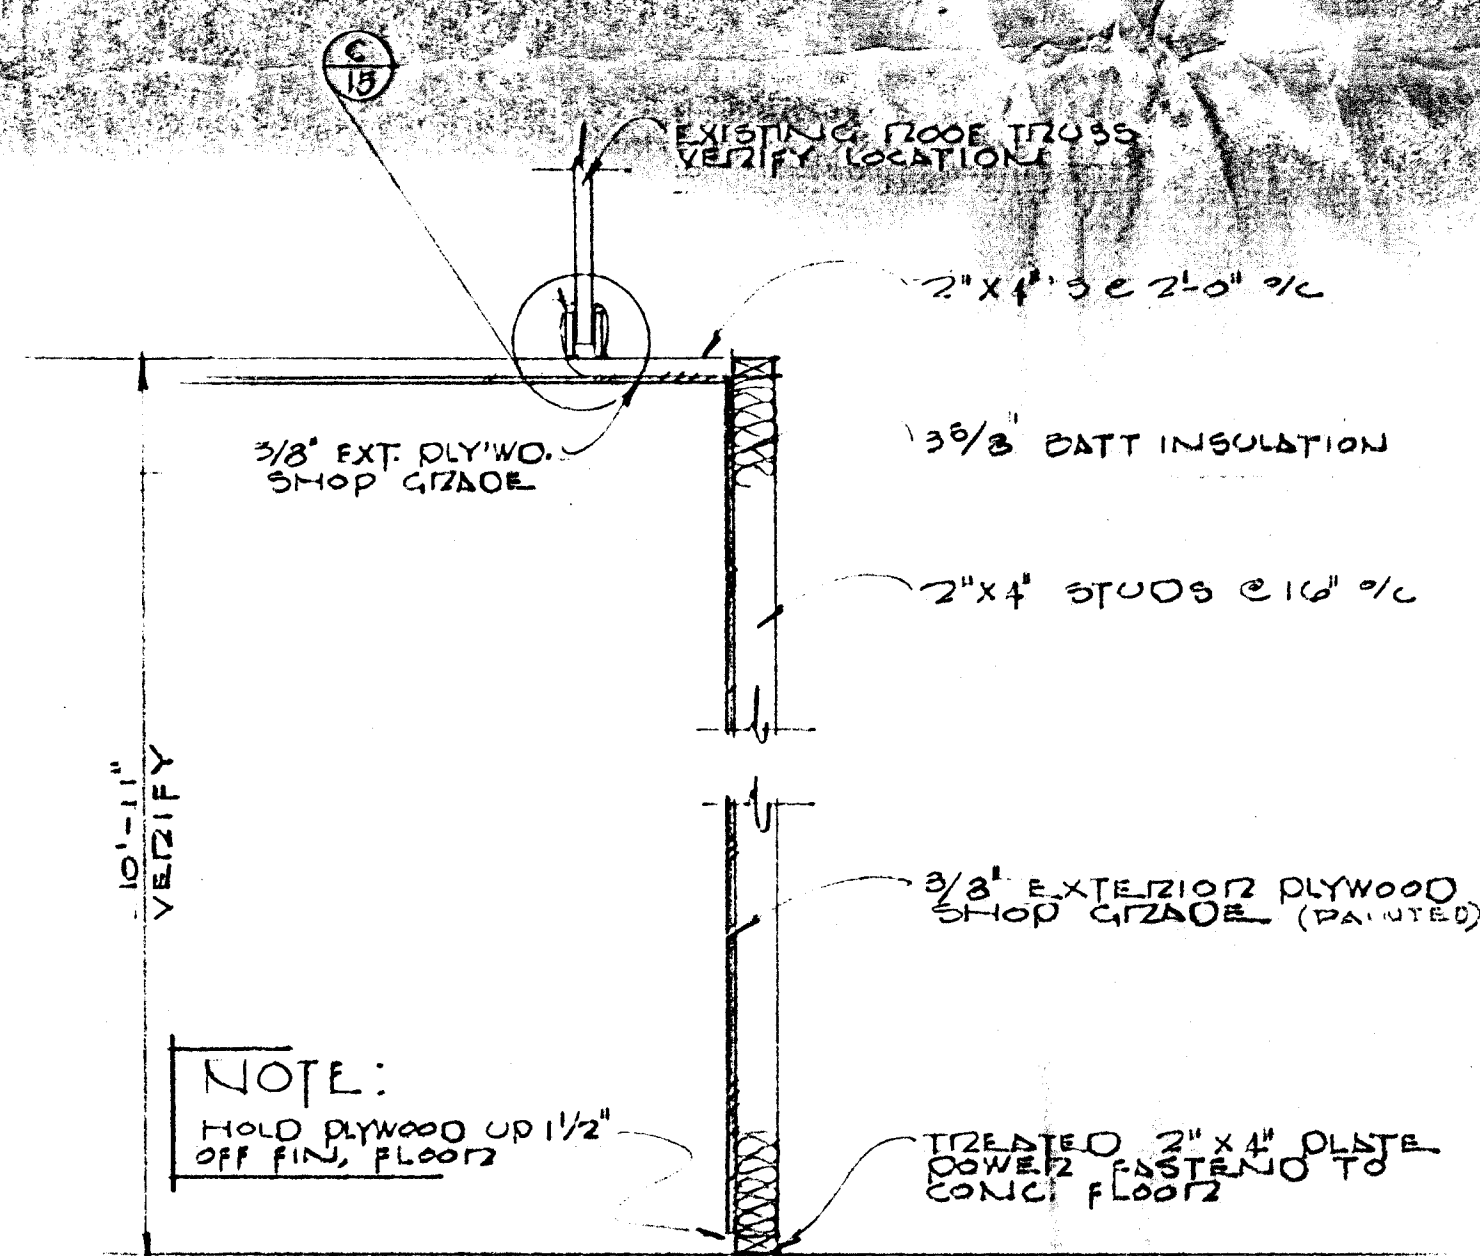


SECTION A

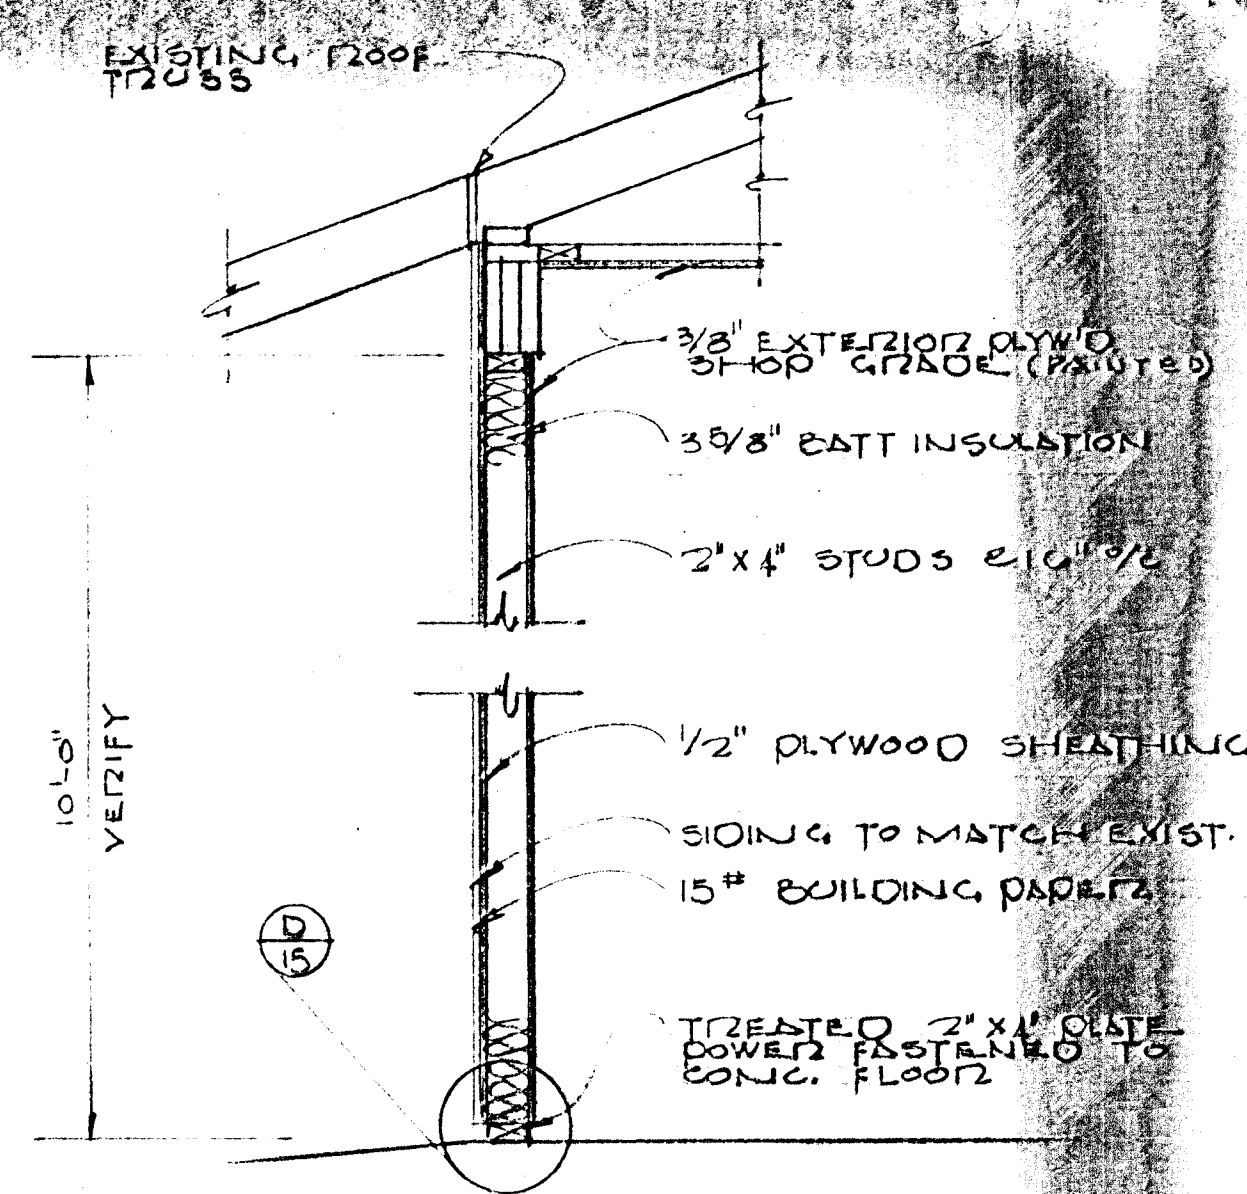


SECTION B

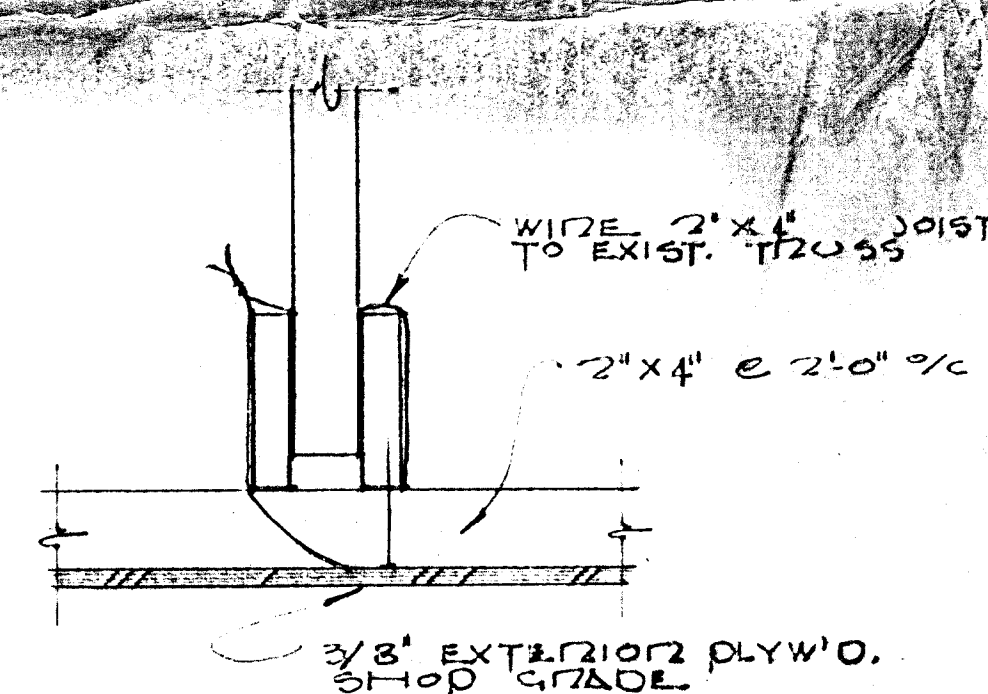

DETAIL C
3" = 1'-0"

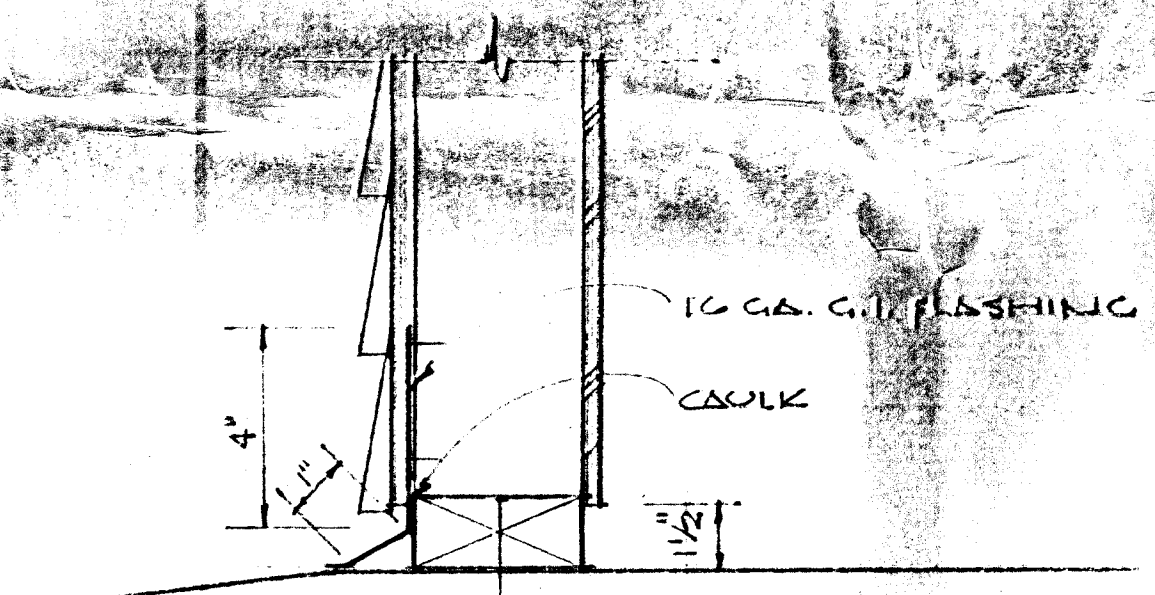

DETAIL D
3" = 1'-0"

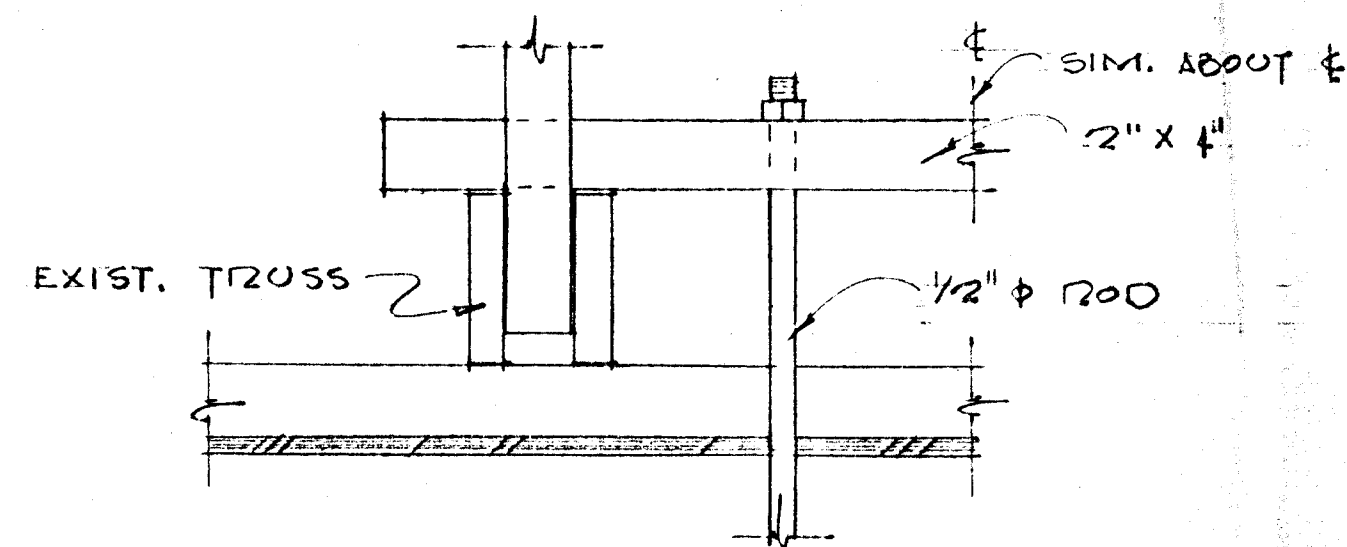

DETAIL E
3" = 1'-0"